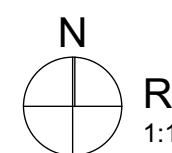
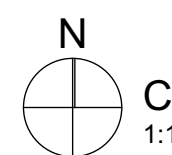
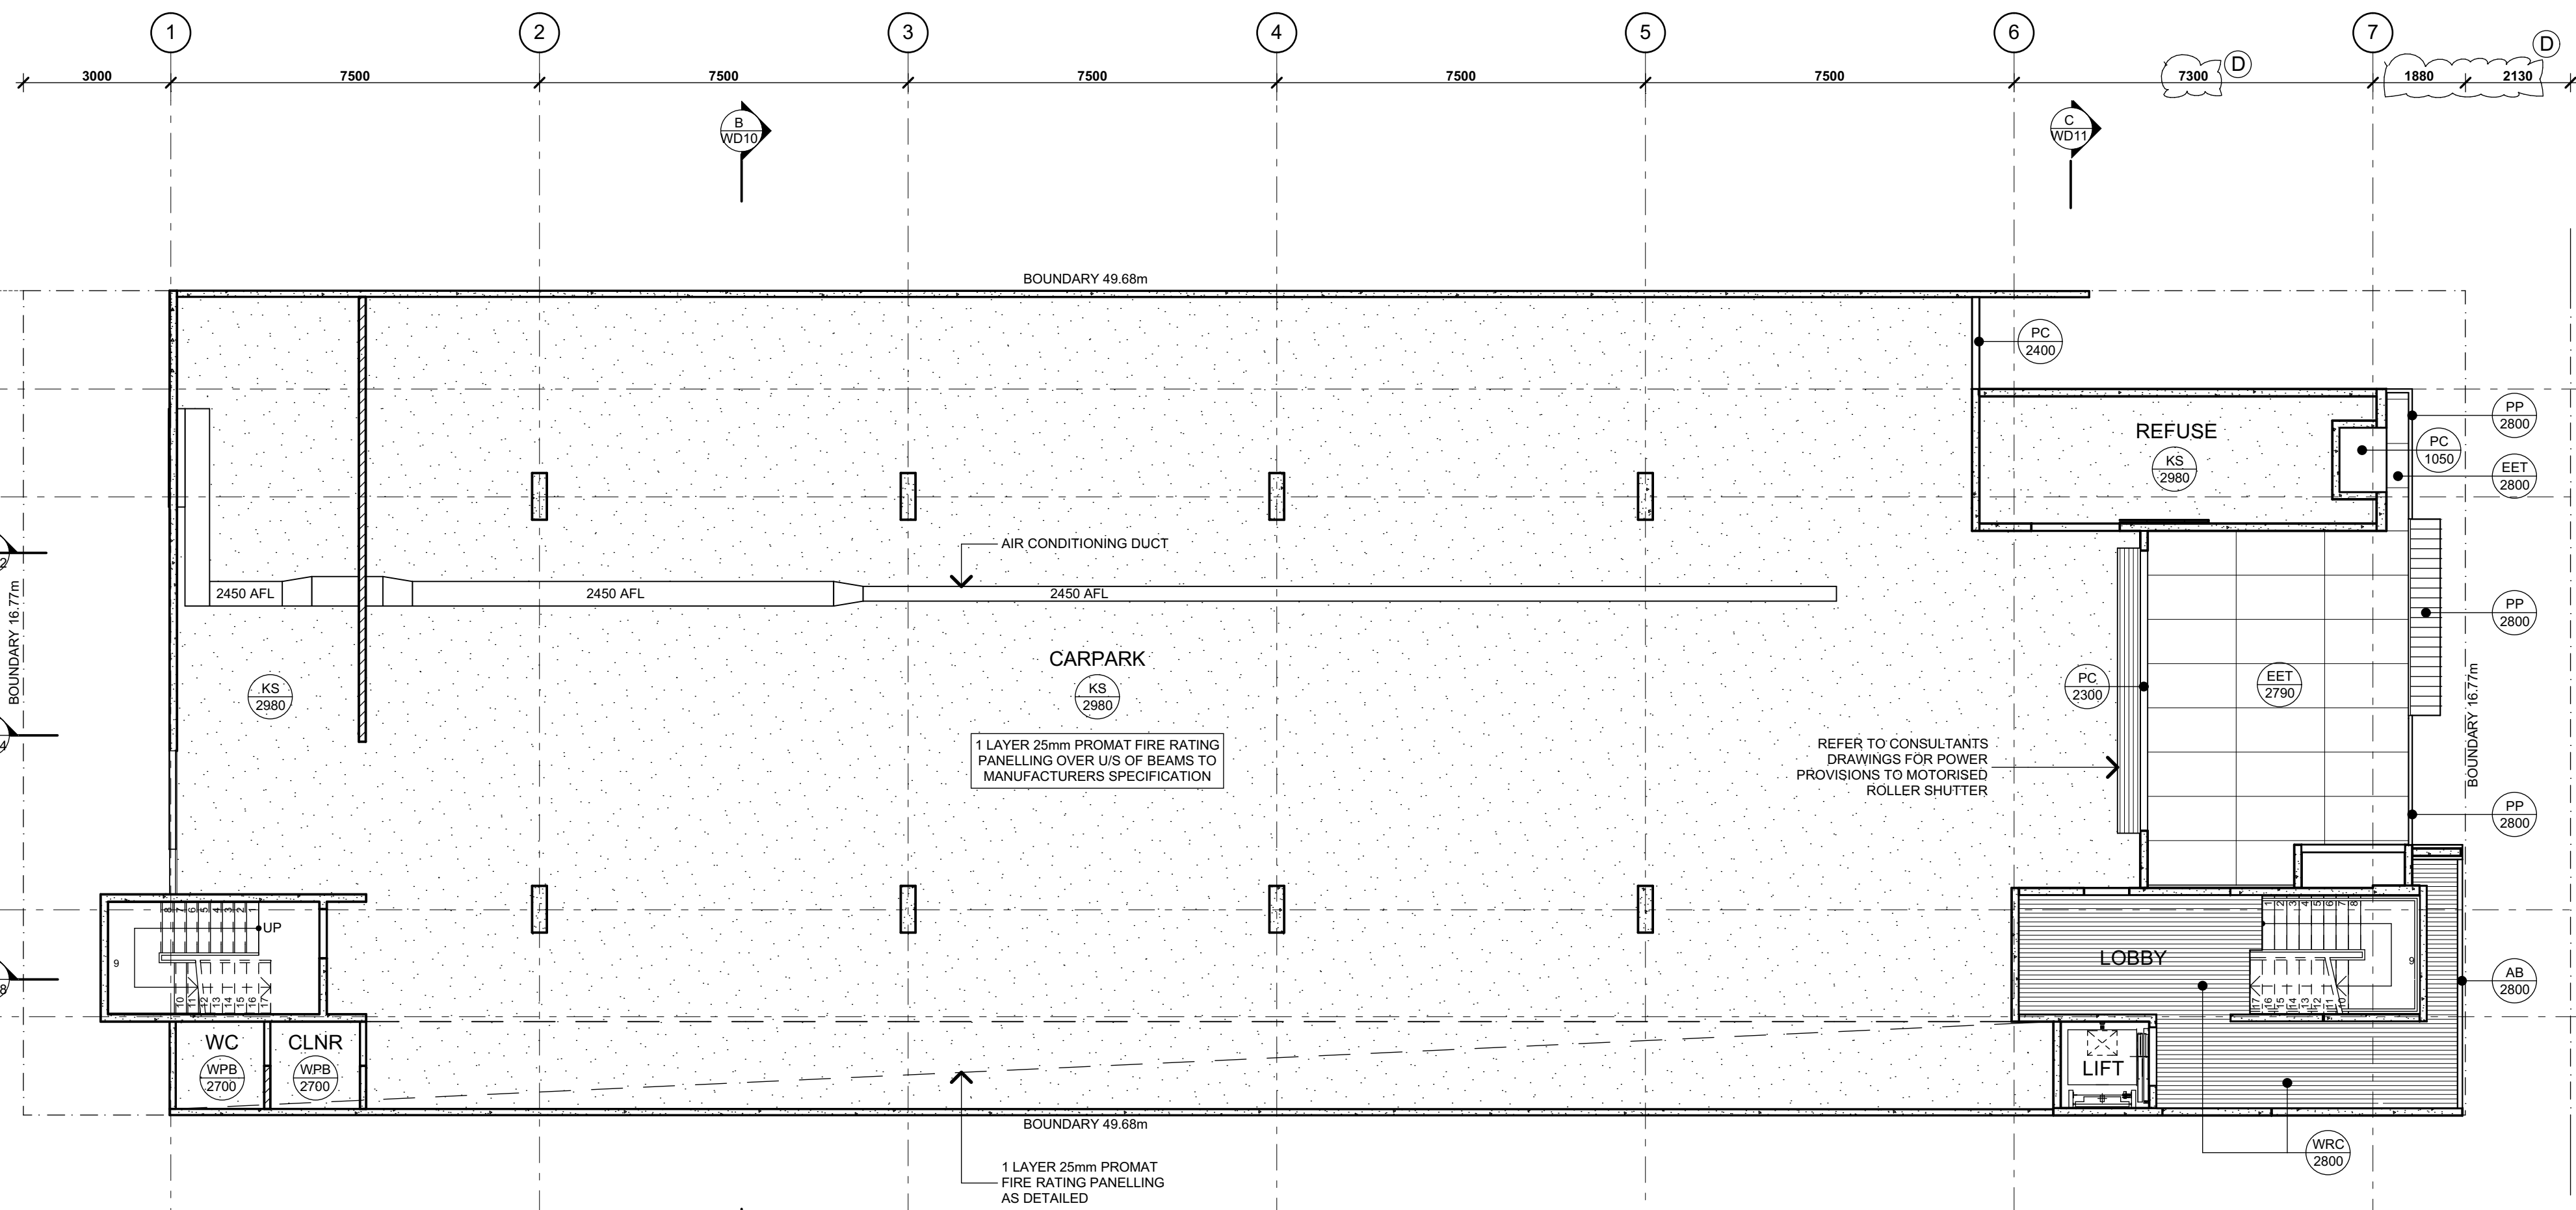


LEGEND - ROOF PLAN

ZKL	ZINCALUME KLIP-LOK 700 HI STRENGTH 0.48 BMT ROOF SHEETING FIXED TO STEEL ROOF STRUCTURE TO MANUFACTURERS DETAILS.
CKL	COLORBOND KLIP-LOK 700 HI STRENGTH 0.48 BMT ROOF SHEETING - AS ABOVE
DP	900 PVC DOWNPIPE TO HYDRAULIC SERVICES CONSULTANTS DETAILS.
DP1	1000 S/G PVC DOWNPIPE TO HYDRAULIC SERVICES CONSULTANTS DETAILS. REFER TO CIVIL ENGINEERS DRAWINGS FOR STORMWATER CONNECTION DETAILS.
DP2	1500 S/G PVC DOWNPIPE TO HYDRAULIC SERVICES CONSULTANTS DETAILS. REFER TO CIVIL ENGINEERS DRAWINGS FOR STORMWATER CONNECTION DETAILS.
DP3	500 S/G PVC DOWNPIPE CONCEALED IN WALL AND FLOOR. CONNECT TO STORMWATER SYSTEM TO HYDRAULIC SERVICES CONSULTANTS DETAILS.
BG.1	450 x 150MM ZINCALUME BOX GUTTER ON SPANDEK GUTTER BOARD AND ADJ. STRAPS @ 900MM MAX. CTS.
BG.2	450 x 120MM ZINCALUME BOX GUTTER ON SPANDEK GUTTER BOARD AND ADJ. STRAPS @ 900MM MAX. CTS.
BG.3	300 x 120MM ZINCALUME BOX GUTTER ON SPANDEK GUTTER BOARD AND ADJ. STRAPS @ 900MM MAX. CTS.
BG.4	500 x 100MM ZINCALUME BOX GUTTER ON SPANDEK GUTTER BOARD AND ADJ. STRAPS @ 900MM MAX. CTS.
EJ	EXPANSION JOINT IN BOX GUTTER
OF	750 OVERFLOW PVC PIPE
GS	PROPRIETARY GUTTA SUMP WITH LEAF GUARD INSTALLED TO MANUFACTURERS SPECIFICATION. LOW PROFILE WHERE REQUIRED.
S	50MM SETDOWN TO BOX GUTTER AT OUTLET LOCATIONS
RAH	1000x800MM ROOF ACCESS HATCH WITH TWIN STRUTS COMPLETE WITH ALUMINIUM FRAMED FOLD DOWN STEP LADDER AS SPECIFIED.
BL	ALUMINIUM FRAMED BALUSTRADE AS DETAILED
RW	REINFORCED FIBRE ROOF WALKWAYS SPECIFIED.
SL	STATIC LINE FALL ARREST SYSTEM AS SPECIFIED (CORRECT SAFETY OF EQUAL)
AP	ANCHOR POINT FALL ARREST SYSTEM AS SPECIFIED (CORRECT SAFETY OF EQUAL)
CS	COLORBOND SLAT SCREENS AS SPECIFIED
CC	COLORBOND PARAPET CAPPING
CF	COLORBOND FLASHING
ZF	ZINCALUME FLASHING
S.COL	STEEL STUB TO ENGINEERS DETAILS. DEKTTITE WEATHERSEALS TO ROOF PENETRATIONS.
P	POWDERCOATED STEEL POST TO ENGINEERS DETAILS.

ROOF PLAN
1:100CEILING PLAN - LEVEL 0
1:100

LEGEND - CEILING PLAN

FPB (2700)	CEILING FINISH
FPB	CEILING HEIGHT AFFL
WPB	13mm FLUSHED PLASTERBOARD CEILING LINING
WPB	13mm WATERPROOF FLUSHED PLASTERBOARD CEILING LINING
PBH	13mm FLUSHED PLASTERBOARD LINED BULKHEAD
FF1	16mm FLUSHED FYRCHECK CEILING LINING
FF2	2 x 13mm FLUSHED FYRCHECK CEILING LINING
VB	6mm SQUARE SET FLUSHED VILLABOARD LINING
KS	40mm KINGSPAN KOOLTHERM K10 WHITE FACED
EET	1800 x 900mm EXPRESSED JOINT EXOTEC CEILING SYSTEM
WRC	12mm WESTERN RED CEDAR
CCD	COLORBOND MID-CORRUGATED DECKING
CLL	COLORBOND LONGLINE CLADDING
PP	POWERPANEL
AB	ALUCOBOND CAPPING
PC	PRECAST CONCRETE
NC	NO CEILING
AP	ACCESS PANELS SCHEDULED NOMINAL 600 x 600mm
EG	EXHAUST GRILLE TO CONSULT. DETAILS
AF	A/C OUTSIDE AIR FAN
RAL	1000 x 800MM ROOF ACCESS ALUM. FRAMED FOLD DOWN STEP LADDER AS SPECIFIED.

NOTE:

SQUARE SET ALL WALL CEILING JUNCTIONS TYP.

ALL INSULATION INCLUDING THERMAL AND ACOUSTIC AS SCHEDULED.

REFER TO ENG'S DETAILS FOR SETOUT OF ALL ACCESS HATCHES AND EXHAUST VENT LOCATIONS.
CONFIRM WITH ARCHITECT BEFORE PROCEEDING WITH INSTALLATION.

D	24.02.2017	DIMENSIONS CLARIFIED AS CLOUDED	JS
C	18.11.2016	ISSUED FOR CONSTRUCTION	JS
B	12.10.2016	STATIC LINE SYSTEM EXTENDED, ANCHOR POINTS ADDED, EXTENT OF WALKBOARDS AND BALUSTRADE REVISED, SANITARY FACILITIES ADDED TO GROUND LEVEL.	JS
A	16.09.2016	ISSUED FOR BUILDING RULES CONSENT	JS
Issue	Date	Amendments	By



Nelson

Architecture
Interior design
Project Management11 Eliza St. Adelaide SA 5000
P +618 8231 4434
F +618 8211 7701
E nelson@nelsonarchitects.com.au

Project

130 CHURCHILL RD APARTMENTS
130 Churchill Road
Prospect SA 5082

Drawing Title

ROOF + CEILING PLAN L.0

Drawn	Checked	Scale
JG JS	JN	As Shown
Date Created	CAD File Name	
22.07.16	02130 WD	
Drawing Number	Issue	
02130 WD04	D	

Copyright of design and drawings are reserved. The contractor shall verify all dimensions and levels before commencing any works or shop drawings. Refer any discrepancies to the Architect. A printed copy of this drawing may not be to scale.
A.C.N. 008 215 558

Nelson Architects Pty Ltd