


GROUND FLOOR LIGHTING LAYOUT
SCALE 1:100

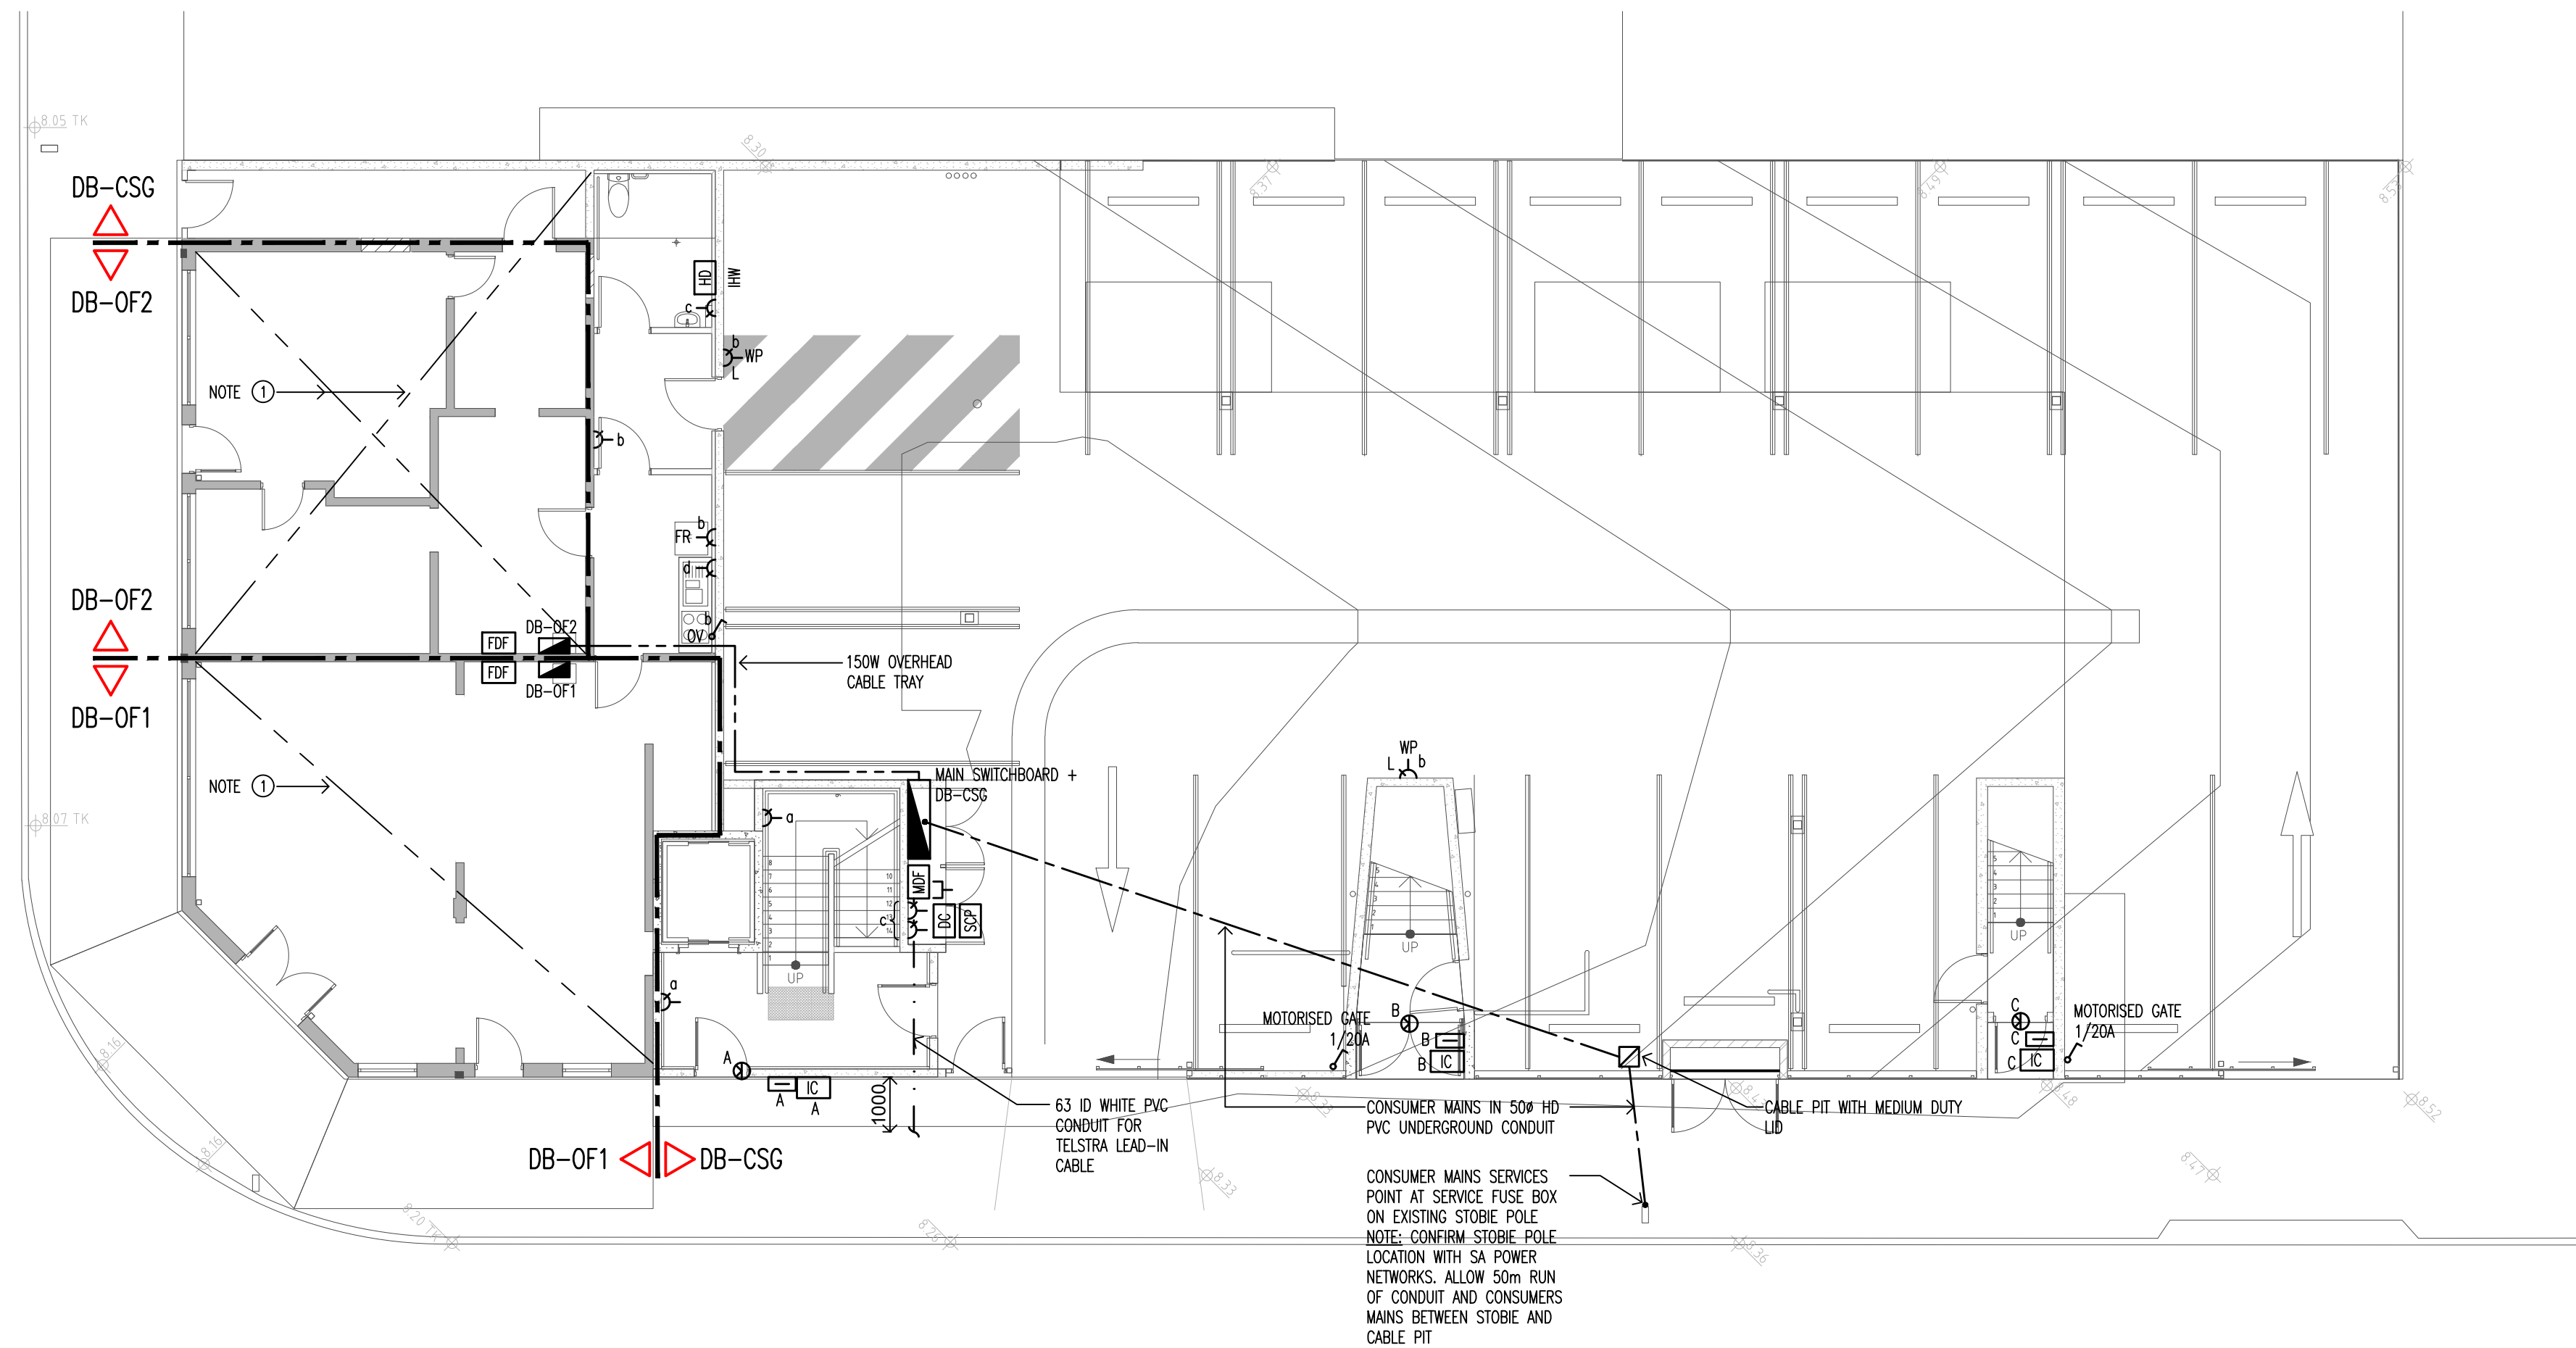

GROUND FLOOR POWER LAYOUT
SCALE 1:100

NOTES

- REFER TO BUILDING OWNER/ARCHITECTS DRAWINGS FOR LAYOUT AND DETAILS OF SERVICES IN THIS AREA.
- CONFIRM LOCATIONS OF ALL DISTRIBUTION BOARDS WITH BUILDING OWNER BEFORE COMMENCING INSTALLATION.
- CONFIRM LOCATIONS OF ALL FITTINGS WITH SUPERINTENDENT BEFORE COMMENCING INSTALLATION.

REV'N	DESCRIPTION	DATE	CHK'D
P3	FOR REVIEW - CHANGES AS CLOUDED	21.08.17	BF
P2	FOR REVIEW - CHANGES AS CLOUDED	26.04.17	BF
P1	FOR REVIEW	19.04.17	BF

PO Box 200
Glen Osmond,
S.A. 5064

Telephone 0412 380 922
Email sabect@ozemail.com.au




CLIENT



PROJECT
**PROPOSED DEVELOPMENT at
147 MARION RD.,
RICHMOND**

DRAWING
**GROUND FLOOR LIGHTING
AND POWER OUTLET**

ELECTRICAL SERVICES

SCALE 1:100		DATE MARCH 2017	
	DESIGNED BF	DRAWN MC	No. IN SET 2 of 4
	DRAWING NUMBER A0733-1S-S02		
			REVISION P3

FOR APPROVAL