




 



 
 









 
 
 



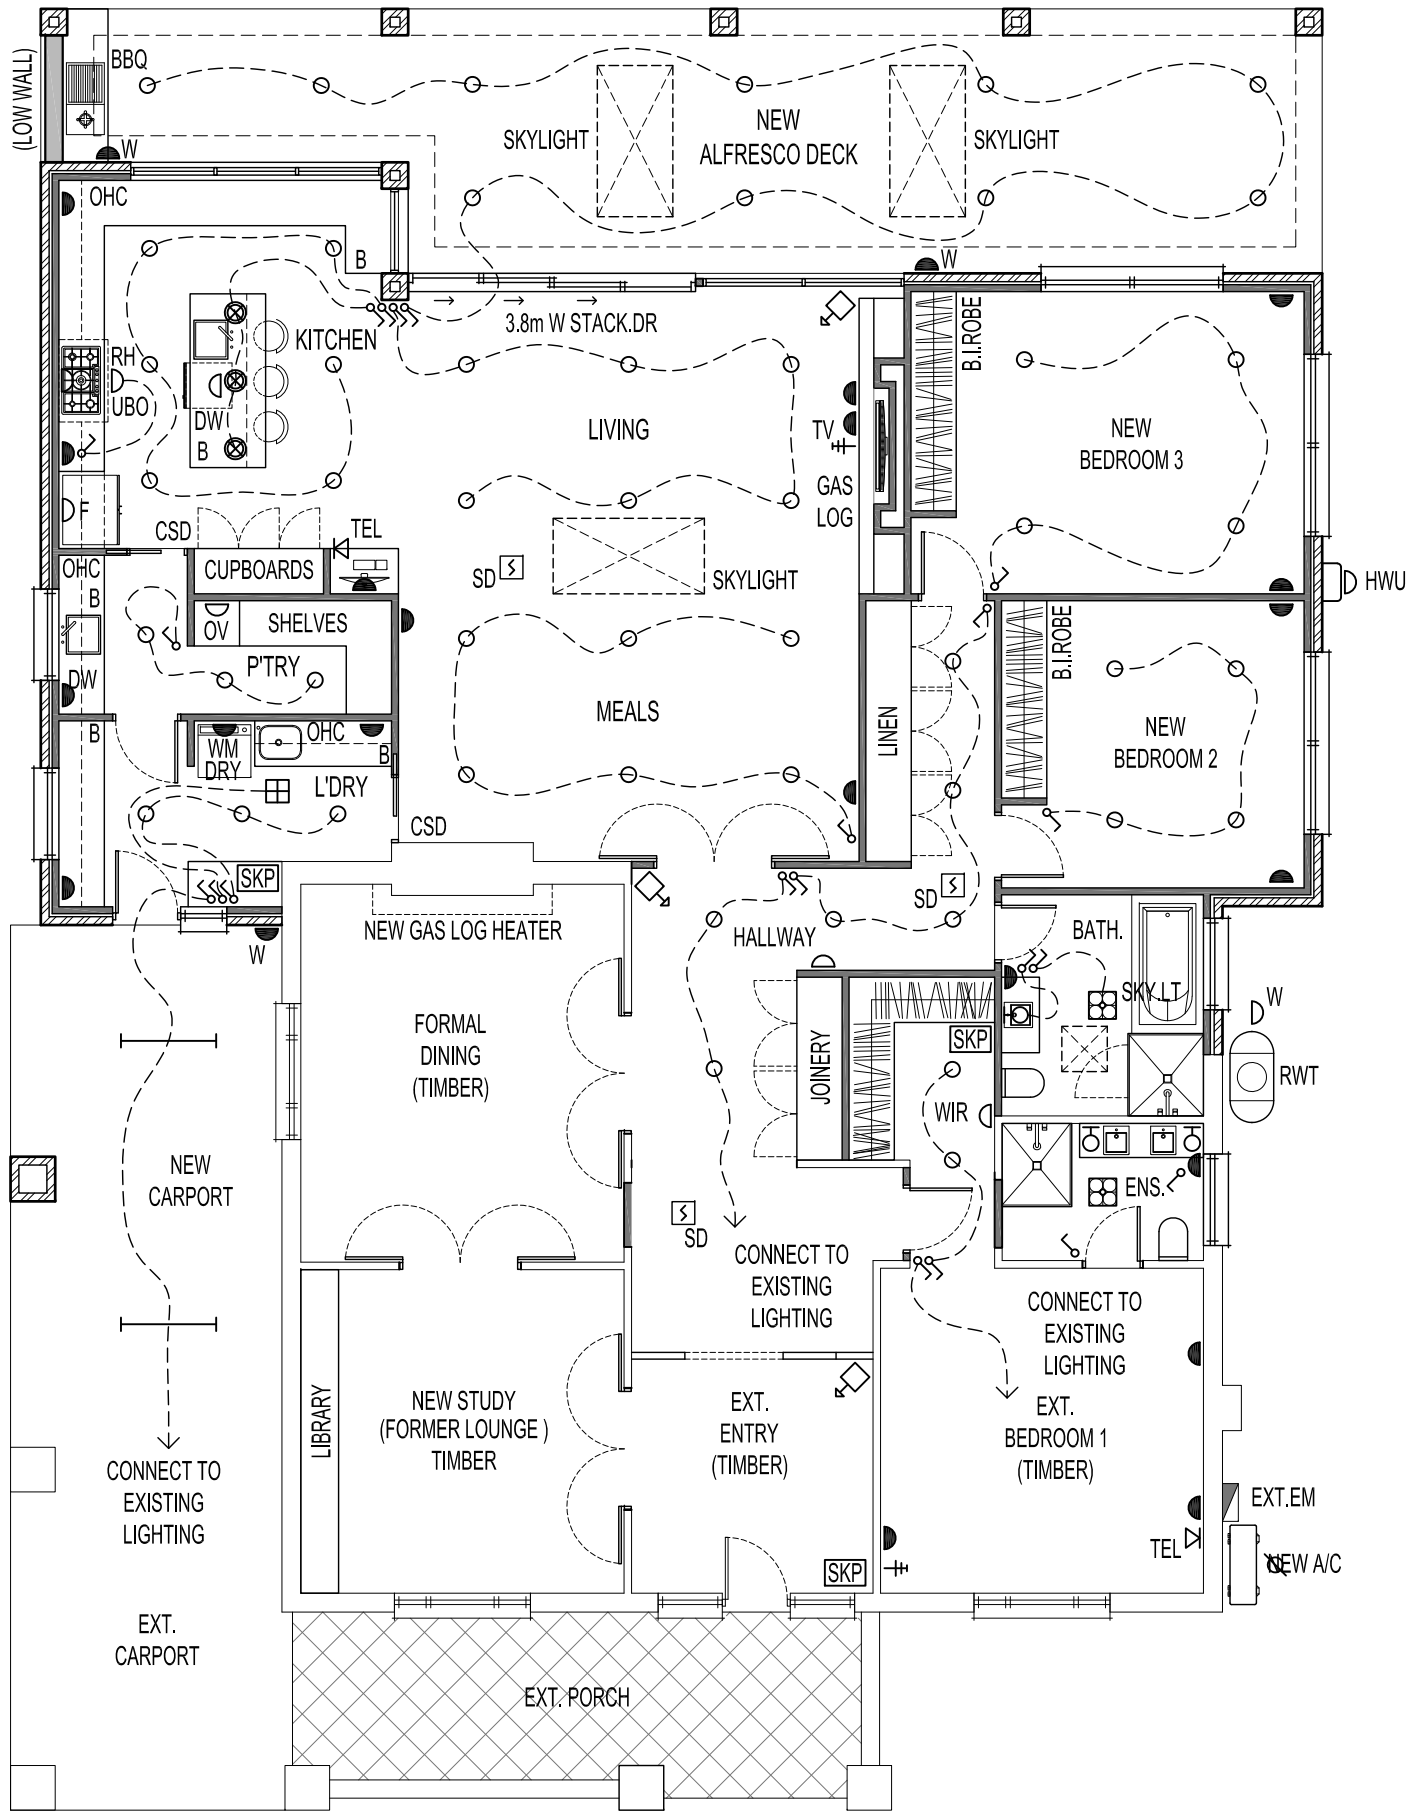


ELECTRICAL LEGEND		
REFER TO FINISHES SCHEDULE (IF APPLICABLE)		LOCATION
 DB	DISTRIBUTION BOARD	WALL MOUNTED
	SINGLE GPO OUTLET	200mm ABOVE FFL
	DOUBLE GPO OUTLET	200mm ABOVE FFL
	WEATHERPROOF SINGLE SWITCH GPO OUTLET	1100mm ABOVE FFL
	DEDICATED SINGLE GPO OUTLET FOR FRIDGE	1100mm ABOVE FFL
	DEDICATED SINGLE GPO OUTLET FOR DISHWASHER	ADJACENT EQUIPMENT
	DEDICATED SINGLE GPO OUTLET FOR RANGEHOOD	1800mm ABOVE FFL
	DEDICATED SINGLE GPO OUTLET FOR LAUNDRY	1100mm ABOVE FFL
	DEDICATED SINGLE GPO OUTLET FOR GARAGE	SURFACE MOUNTED
	SINGLE PHASE ISOLATED FOR HOT WATER UNIT	ADJACENT EQUIPMENT
	SINGLE PHASE ISOLATED FOR AIR CONDITIONING	ADJACENT EQUIPMENT
	TELEPHONE OUTLET	ADJACENT EQUIPMENT
	TELEVISION ARIEL OUTLET	200mm ABOVE FFL
	SECURITY KEYPAD PANEL	1500mm ABOVE FFL
	SECURITY CONTROL PANEL	WALL MOUNTED
	SECURITY SENSOR	SURFACE MOUNTED
	ONE-WAY LIGHT SWITCH	1100mm ABOVE FFL
	TWO-WAY LIGHT SWITCH	1100mm ABOVE FFL
	CIRCUIT/SWITCH LINE	WHERE REQUIRED
	FLUORESCENT LIGHTING	SURFACE MOUNTED
	BATTEN FIX LIGHT	SURFACE MOUNTED
	RECESSED DOWNLIGHT	CEILING RECESSED
	WALL LIGHT	1800mm ABOVE FFL
	SMOKE DETECTOR	CEILING MOUNTED
	EXHAUST FAN	CEILING RECESSED
	COMBINATION HEAT / FAN / LIGHT	CEILING RECESSED

TIMBER FRAME BRICK VENEER CONSTRUCTION



ALL EXHAUST FANS TO BE  
VENTED TO THE OUTSIDE

## LEGEND

WC	WATER CLOSET (TOILET)
SH	SHOWER
B	BENCHTOP
F	FRIDGE
DW	DISHWASHER
UBO	UNDER BENCH OVEN
OHC	OVERHEAD CUPBOARDS
RH	RANGE HOOD
WM	WASHING MACHINE
CSD	CAVITY SLIDING DOOR
STD	STACKER DOOR
HWU	HOT WATER UNIT
A/C	AIR CONDITIONER
SD	SMOKE DETECTOR
RWT	RAINWATER TANK
EM	ELECTRICAL METERBOARD
GM	GAS METER
DP	DOWNPIPE

## ELECTRICAL NOTES

ALL ELECTRICAL WORK, INCLUDING  
WIRING AND INSTALLATION, CARRIED OUT  
TO BE IN ACCORDANCE WITH AS3000

THIS DRAWING IS TO BE READ IN  
CONJUNCTION WITH ALL OTHER  
DRAWINGS, DOCUMENTATION, SCHEDULES  
AND SPECIFICATIONS

POSITIONING OF ELECTRICAL LAYOUTS AS  
SHOWN ARE INDICATIVE ONLY AND  
SUBJECTED TO PHYSICAL CONSTRUCTION  
LIMITATIONS

GPO POINTS LOCATIONS TO COMPLY WITH  
AS3000 AND WHERE POSSIBLE BE A  
MINIMUM 300mm FROM FFL UNLESS  
WHERE APPLICABLE LOCATED IN KITCHEN,  
LAUNDRY AND BATHROOM WHERE GPO  
POINTS SHALL BE 400mm FROM THE TOP  
OF BENCHES, BASINS AND SINKS

CONTRACTOR MUST VERIFY WITH  
PROPRIETOR OR ARCHITECT ANY  
DISCREPANCIES OR ALTERATIONS TO THE  
ELECTRICAL LAYOUT BEFORE ANY WORK  
IS COMMENCED


SWITCHBOARD TO BE NON-COMBUSTIBLE  
CONSTRUCTION AND FITTED WITH SMOKE  
SEALS ACCORDINGLY

SMOKE ALARM SYSTEM TO COMPLY WITH  
AS3786 ALL TO BE INTERCONNECTED AND  
TO BE POWERED FROM THE CONSUMER  
MAINS SOURCE WITH 9V BATTERY BACKUP

SMOKE DETECTION SYSTEM TO COMPLY  
WITH AS1670 AND THE NCC

WC EXHAUST FANS TO BE CONNECTED TO  
WC LIGHT SWITCHES

MAINS ELECTRICAL METER & MAINS GAS  
METER SERVICES TO BE LOCATED FOR  
EASY ACCESS FOR READING OF METERS

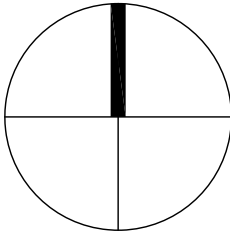

A	28.09.20	FOR APPROVAL	DF
REV	DATE	COMMENT	DRN

# FERRONE

WEB WWW.FERRONE.COM.AU	ABN 96 081 588 758
E-MAIL ARCHITECT@FERRONE.COM.AU	PHONE 0409 374 786
ADDRESS 68 A WINGFIELD ROAD, WINGFIELD, SA, 5013	

ARCHITECT & BUILDING SUPERVISOR

ALL RIGHTS RESERVED. THESE DRAWINGS REMAIN THE INTELLECTUAL  
PROPERTY OF FERRONE ARCHITECTS. ANY REPRODUCTION OF WHOLE OR  
PART THEREOF IS STRICTLY PROHIBITED WITHOUT PRIOR CONSENT. ALL  
DRAWINGS ARE CONCEPTUAL ONLY AND ARE SUBJECT TO CHANGE  
WITHOUT NOTICE. DIMENSIONS AND AREAS ARE APPROXIMATE AND MAY  
VARY ON SITE WITH ACTUAL CONSTRUCTION.  
© 2020 FERRONE ARCHITECTS

## FOR APPROVAL

CLIENT:  
C. LOCKETT & G. WALKER

ADDRESS:  
18 RICHMAN AVENUE  
PROSPECT SA 5082

PROJECT:  
PROPOSED ALTERATION & ADDITION  
TO EXISTING RESIDENCE

SHEET TITLE:  
ELECTRICAL LIGHT & POWER

JOB REF:

20.LOCK.01

DRAWN:

DF

SCALE:

1:100

DRAWING NO.

WD.600

DATE:

MAY 2020

CHECKED:

DF

PAPER:

A2

REVISION:

A

ORIGINAL DRAWING - A2 SIZE SHEET  
SCALE 1:100

METRES

0	1	2	3	4	5	10
---	---	---	---	---	---	----

BUILDER TO CHECK AND CONFIRM ALL  
DIMENSIONS PRIOR TO COMMENCEMENT  
OF CONSTRUCTION