


1 WALL SETOUT - TYPE C GROUND FLOOR

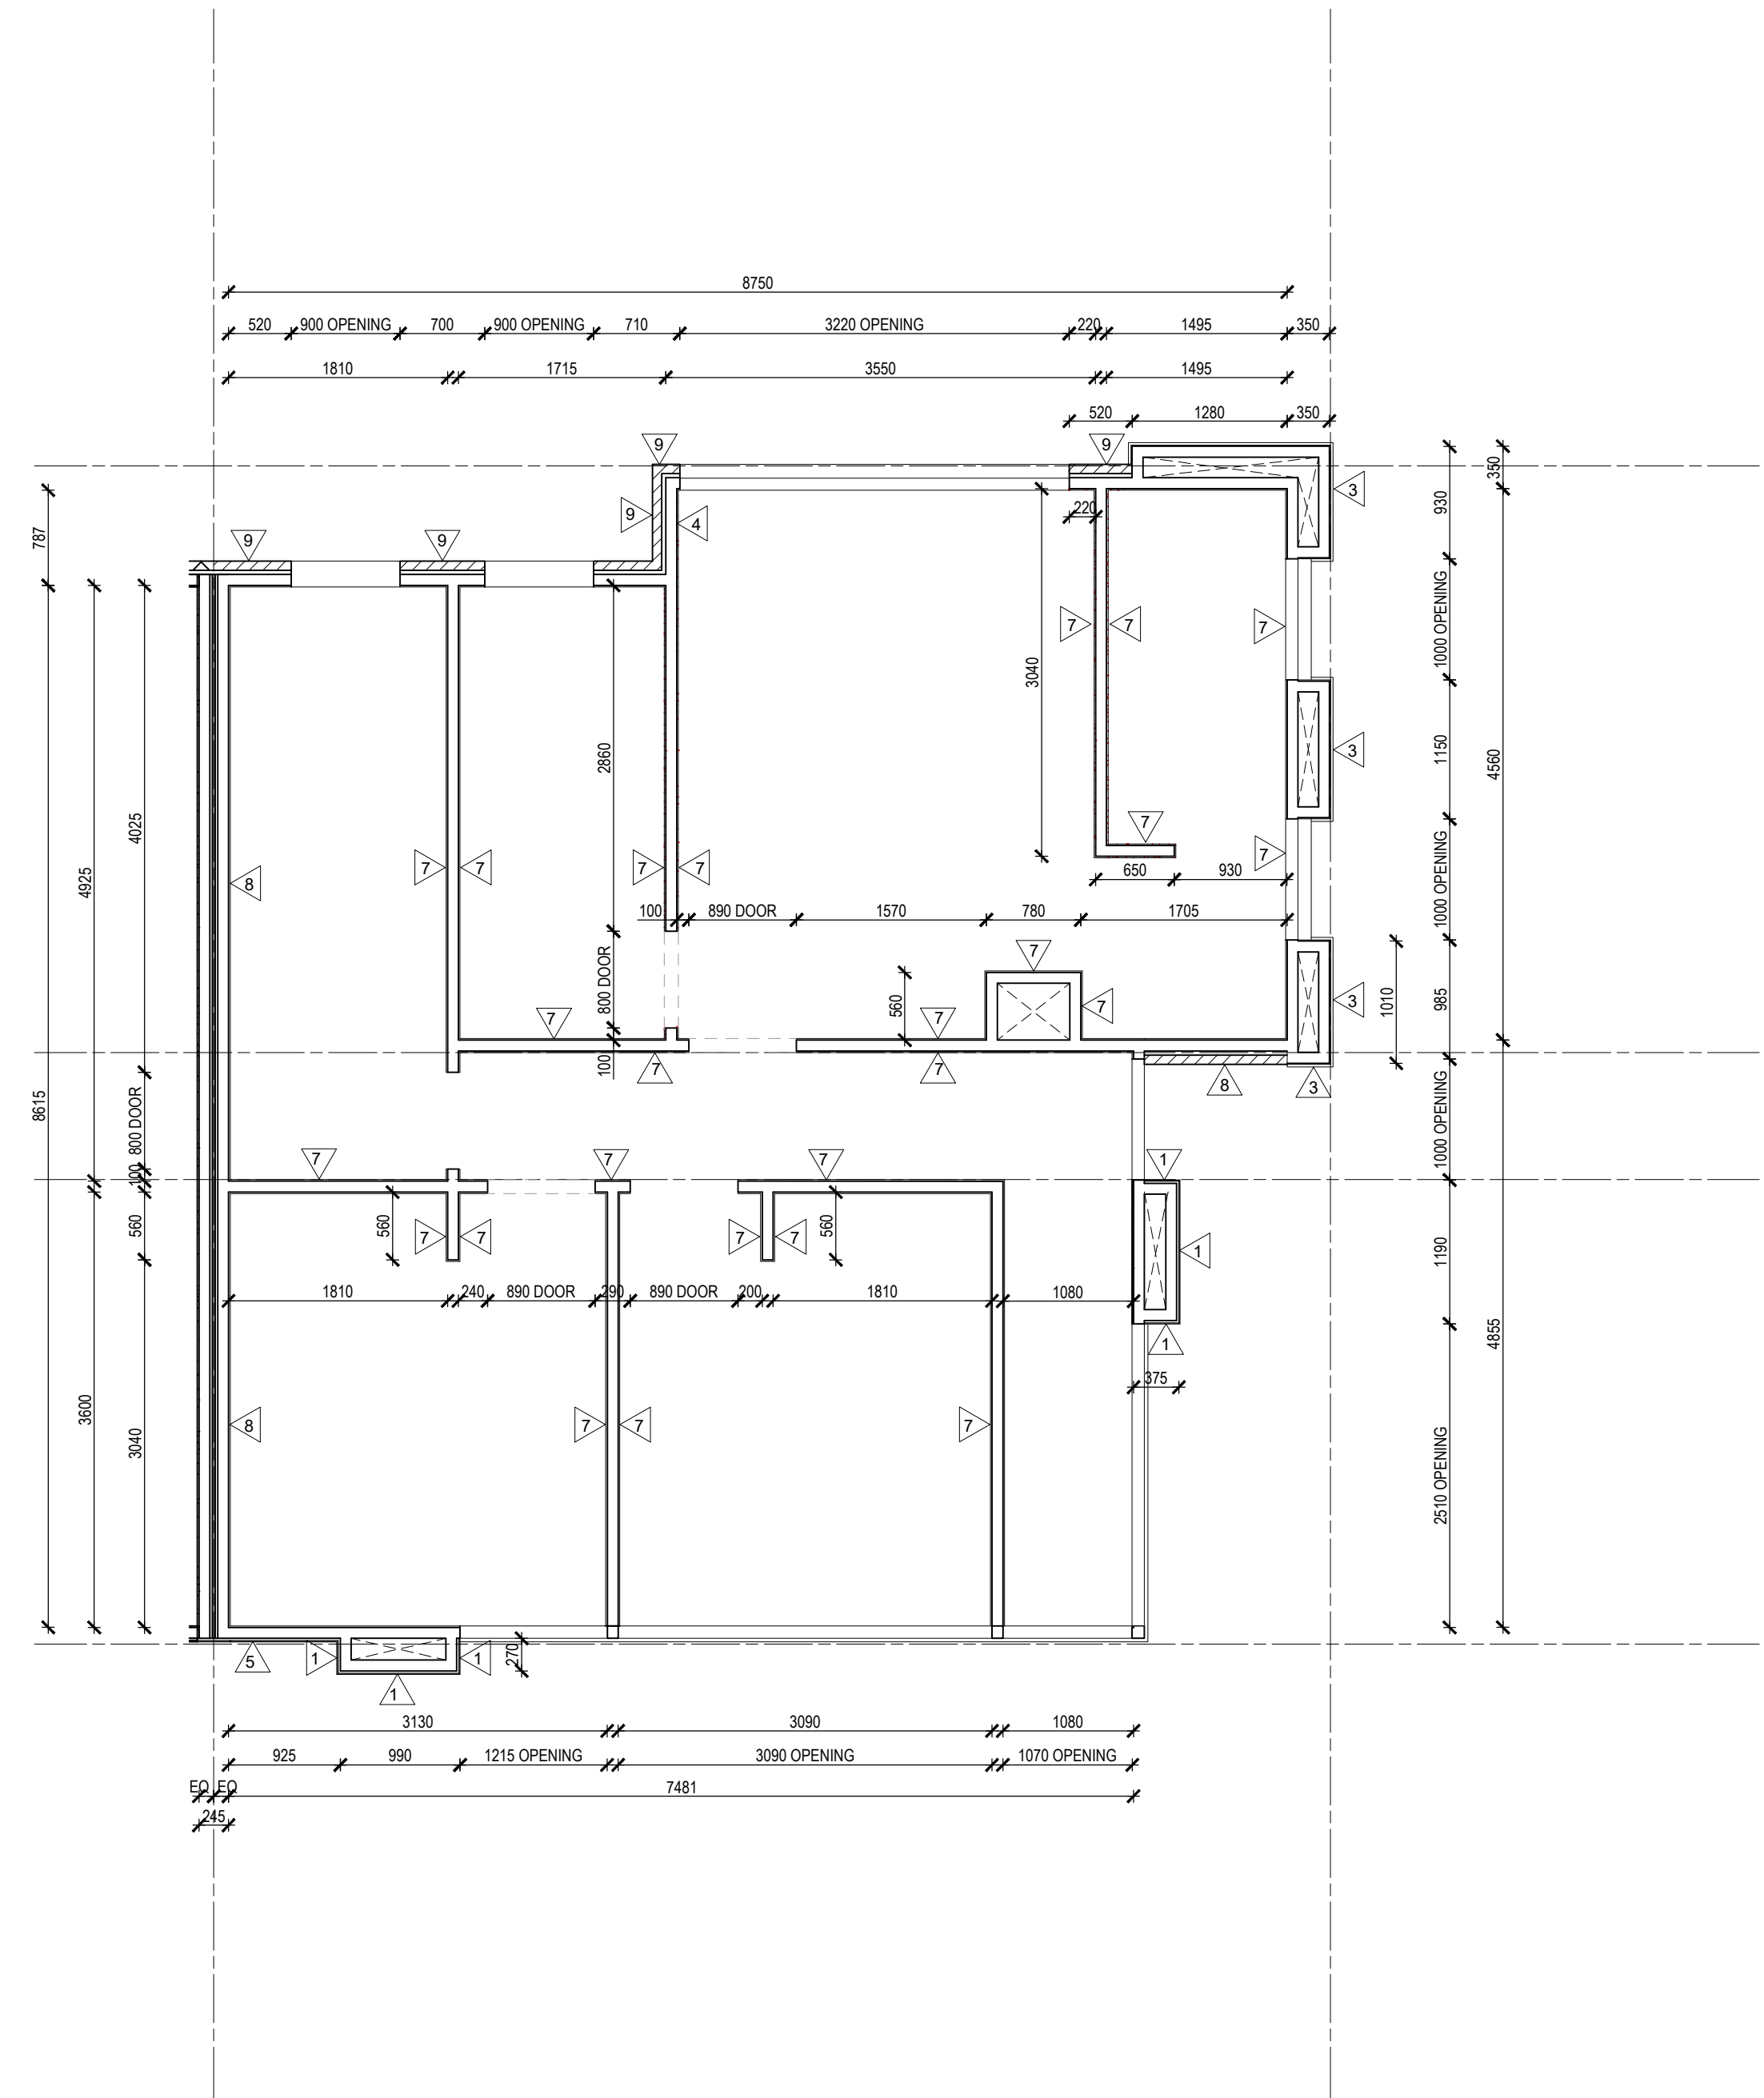

2 WALL SETOUT - TYPE C FIRST FLOOR

- NOTES:
- ELECTRICAL LAYOUT TO CLIENT'S AND BUILDER'S SELECTION.
  - ALL GRID IS JUST A GENERAL REFERENCE. REFER TO GENERAL ARRANGEMENT PLANS FOR GRIDS AND UNIT TYPE LOCATION.

IMPORTANT NOTES: Do not scale from drawings. All dimensions to be checked on site before commencement of work. All discrepancies to be brought to the attention of the Designer. Larger scale drawings and written dimensions take preference. This drawing is copyright and the property of the author, and must not be retained, copied or used without the express authority of NIC DESIGN STUDIO PTY LTD	REVISION	DATE	DESCRIPTION	BY
	3	29/04/2019	ISSUE FOR INFORMATION	NW
FOR CONSTRUCTION	CLIENT HUIDA UNLEY PARK NO.1			
	PROJECT UNLEY ROAD 392-394 UNLEY ROAD, UNLEY PARK 5061			
	DRAWING TITLE WALL SETOUTS - TYPE C GROUND & FIRST FLOORS			
0 1 2	SCALE 1 : 50 @A1	DATE APR 2019	DRAWN NW	CHECKED NW
	JOB 19002	DRAWING A2.325	REVISION 3	