



SCHEMATIC
N.T.S.

LEGEND (SCHEMATIC)


- ISOLATION VALVE
- NON RETURN VALVE
- SPRINKLER EXPOSED
- DRENCHER
- DIESEL FIRE PUMP
- FIRE HOSE REEL
- FIRE HYDRANT
- BOOSTER VALVES
- HYDRANT VALVES

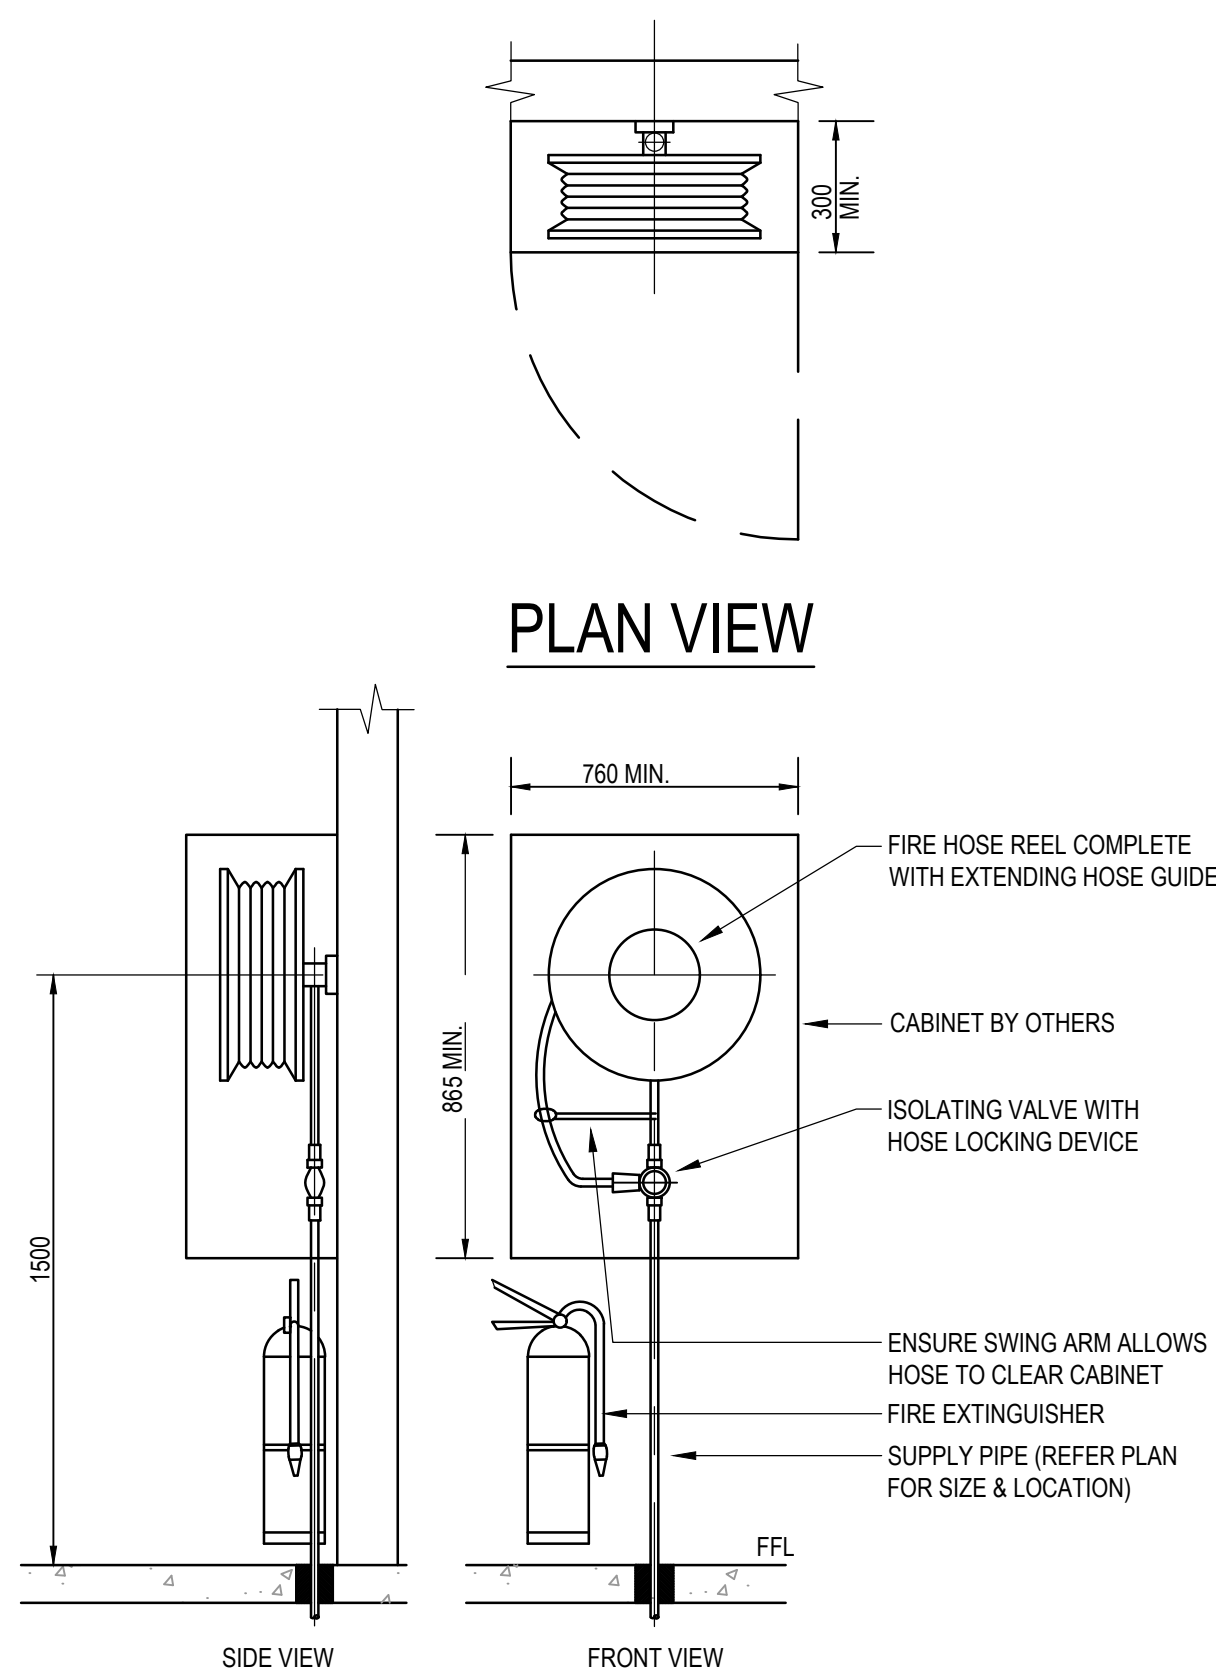

FIRE HOSE REEL DETAIL
NOT TO SCALE

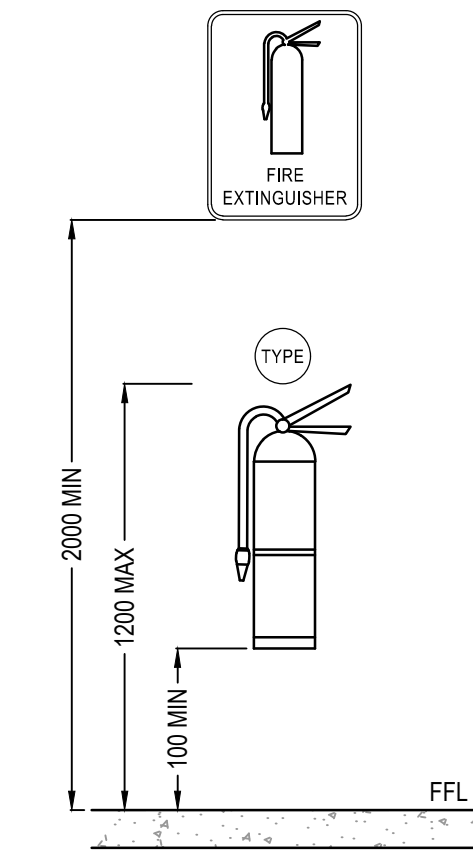

FIRE EXTINGUISHER DETAIL
NOT TO SCALE

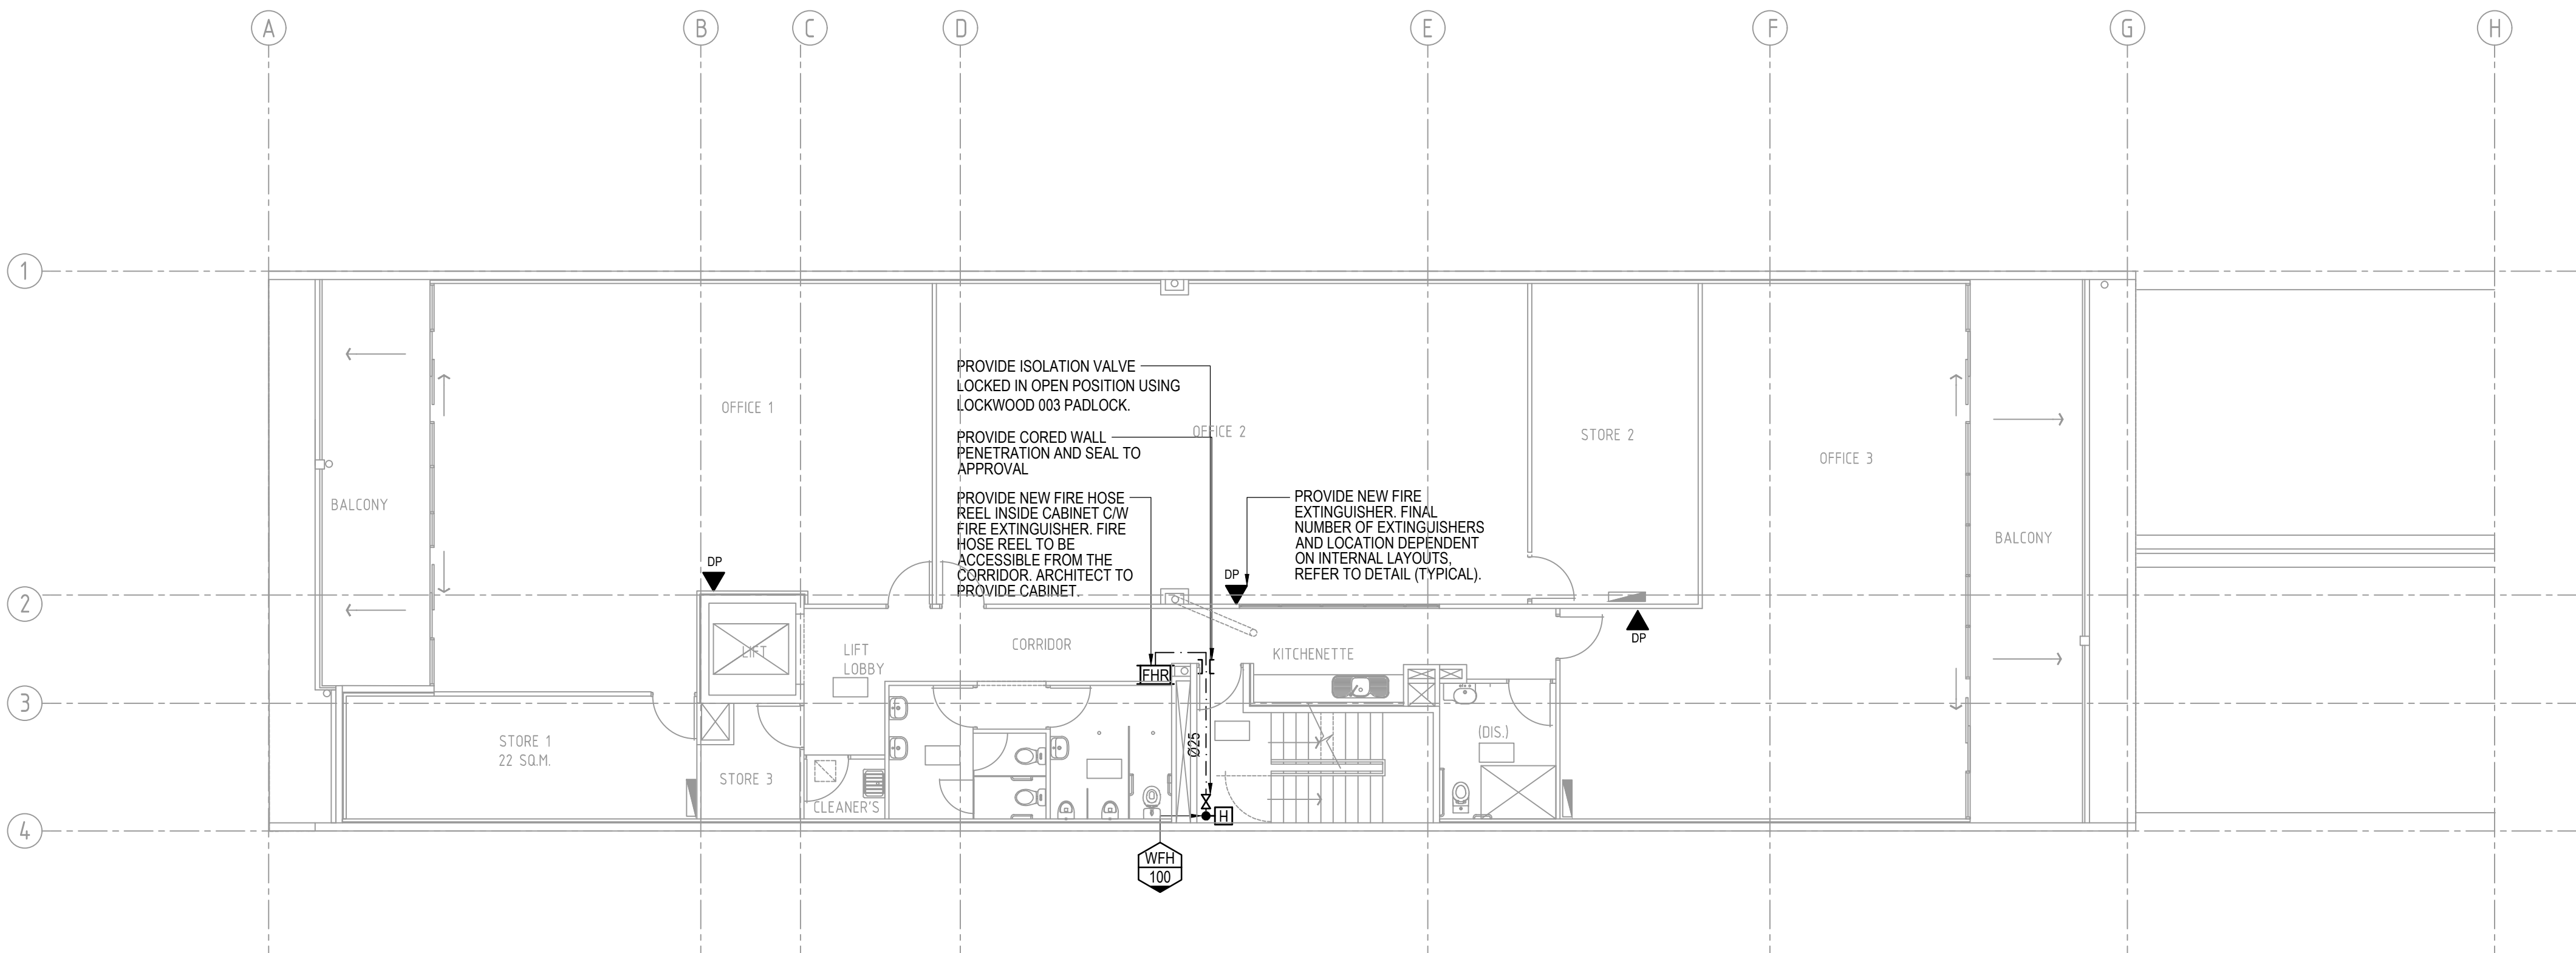

THIRD FLOOR PLAN
SCALE 1:100



BUILDING RULES

1	22-06-18	BUILDING RULES CONSENT						TB	
0	18-05-18	BUILDING RULES CONSENT						TB	
Rev	Date	Issue Description						By	
Project									
PROPOSED COMMERCIAL DEVELOPMENT									
97 KING WILLIAM STREET									
KENT TOWN									
Title									
WET FIRE SERVICES									
THIRD FLOOR LAYOUT,									
SCHEMATIC AND DETAILS									
Architect									
ANTHONYDONATOARCHITECTS 									
Suite 5/59 Fullarton Road Kent Town SA 5087									
t: 08 8364 6888 f: 08 8364 5355 www.adarchitects.com.au									
SECON									
consulting engineers									
456 PULTENEY STREET									
ADELAIDE									
SOUTH AUSTRALIA 5000									
TEL: 08 8223 7800									
engineers@secon.net.au									
A.B.N. 30 613 300 299									
A.C.N. 613 300 299									
© COPYRIGHT SECON PTY. LTD. 2017									
	DRAWN	SRU	CHECKED	NC					
	ENG	SRU	Q.A.	NA					
	DATE	FEB 18	SCALE	1:100 @ A1					
			SHEET	3 OF 4					
DRAWING No.									
B8014-F03									
PLOT DATE: 22/06/2018					Size:	A1		Rev.	1