



THIRD FLOOR PLAN
SCALE 1:100

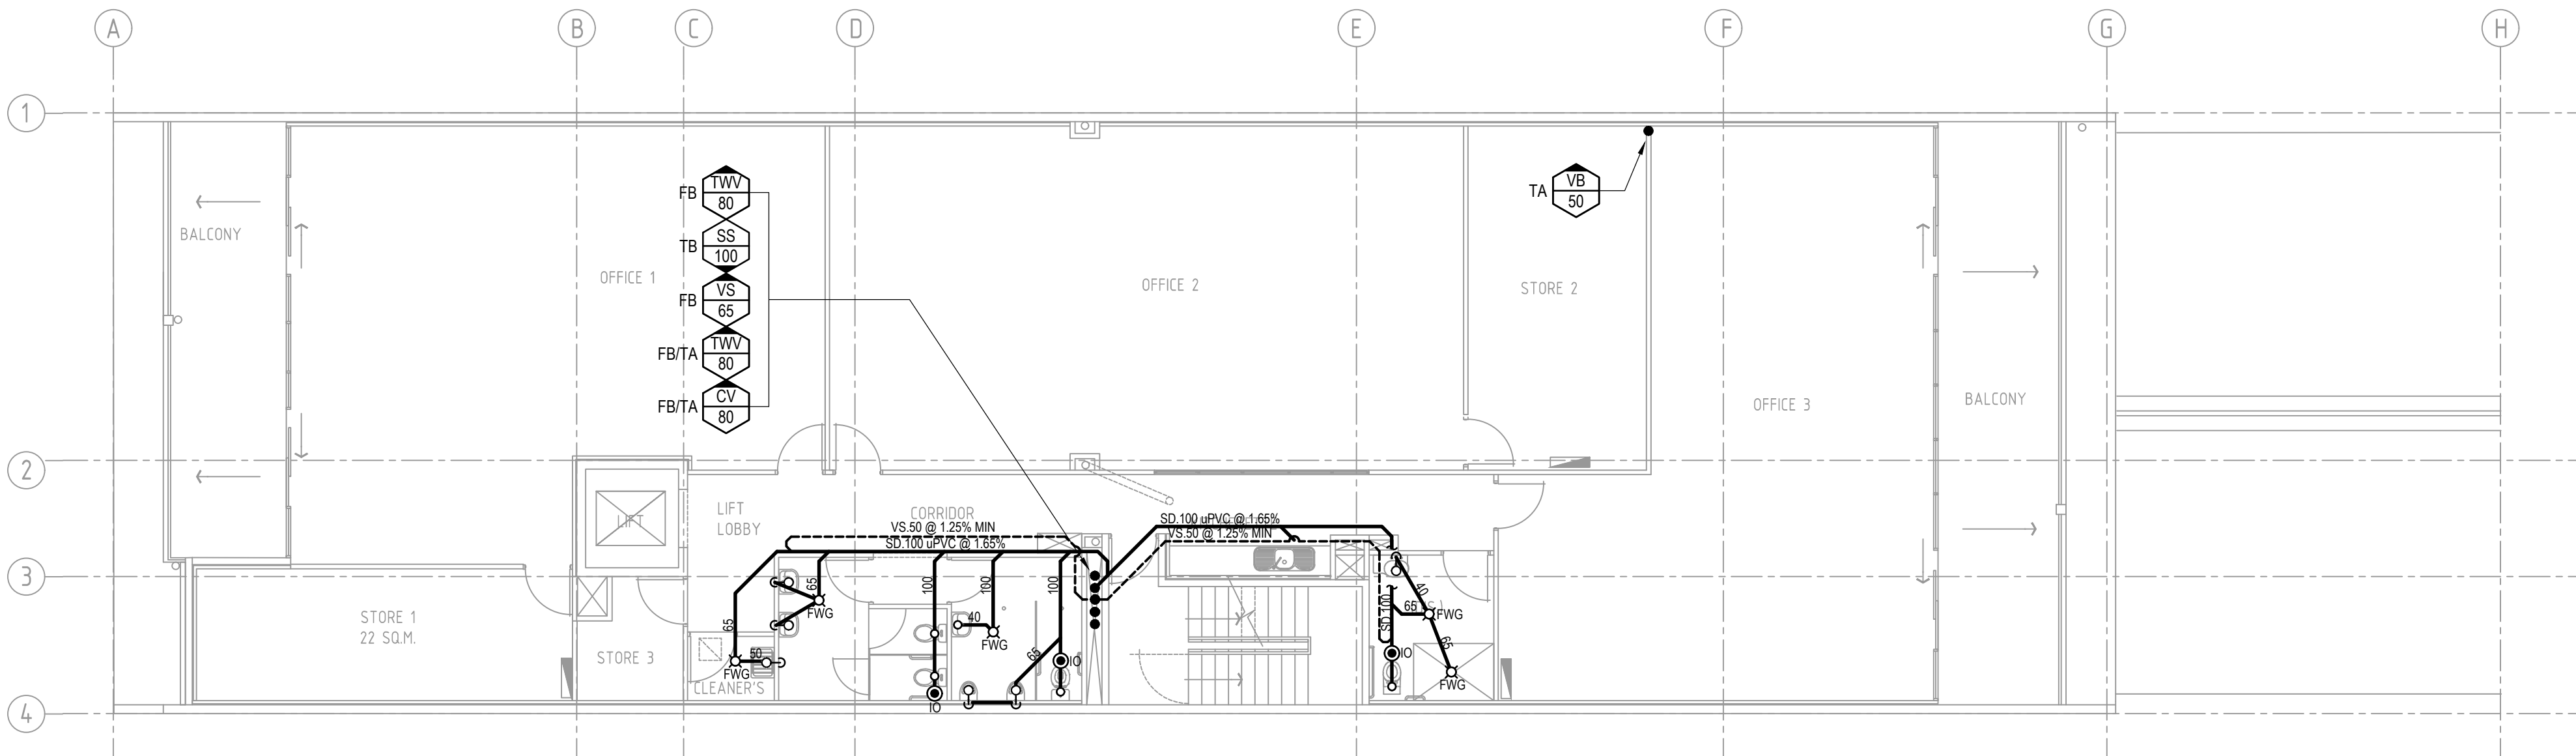

SECOND FLOOR PLAN
SCALE 1:100

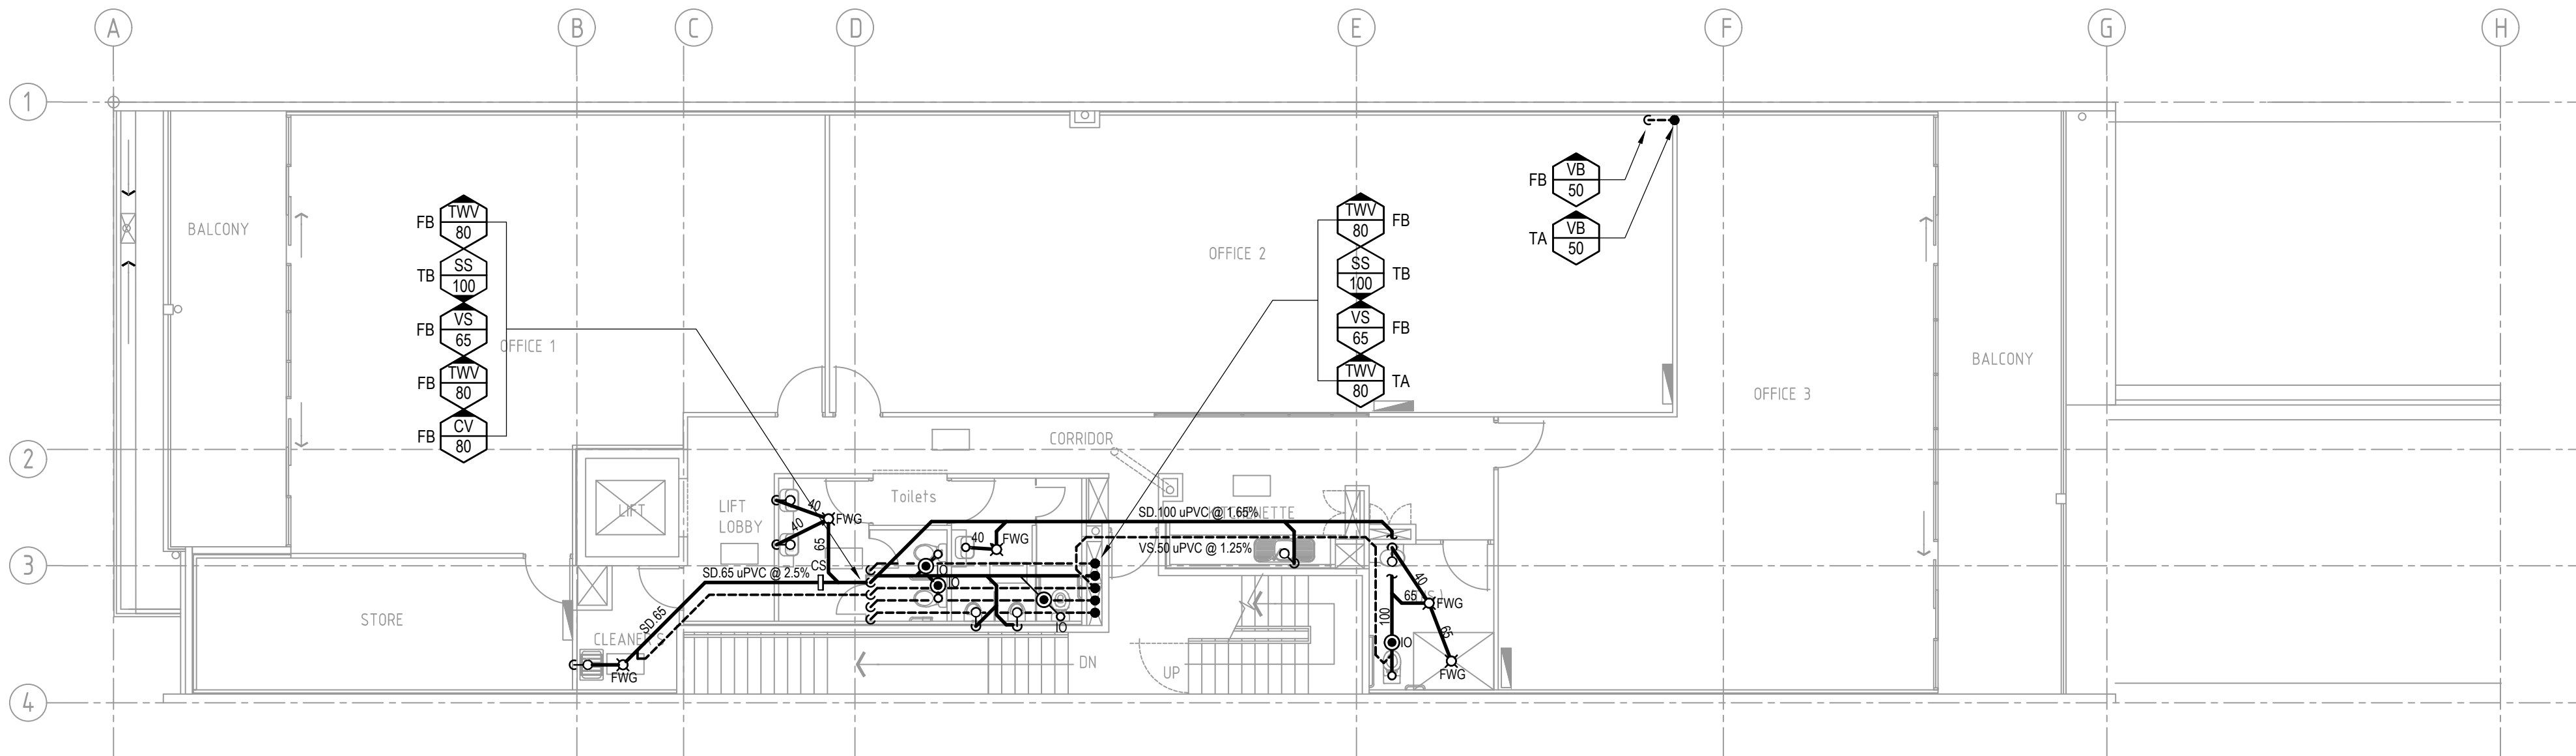

FIRST FLOOR PLAN
SCALE 1:100

Plotted by: Stefan Ruter

ALLOW TO COORDINATE INSTALLATION WITH
ARCHITECT AND JOINERY DETAILS

Rev	Date	Issue Description	By
1	22-06-18	BUILDING RULES CONSENT	TB
0	18-05-18	BUILDING RULES ISSUE	TB

Project
PROPOSED COMMERCIAL
DEVELOPMENT
97 KING WILLIAM STREET
KENT TOWN

Title
HYDRAULIC SERVICES
DRAINAGE - FIRST, SECOND &
THIRD FLOOR LAYOUT(s)

Architect
ANTHONY DONATO ARCHITECTS
Suite 5/59 Fullarton Road | Kent Town SA 5087
t. 08 8364 6888 | f. 08 8364 5355 | www.adarchitects.com.au

SECON
consulting engineers
456 PULTENEY STREET
ADELAIDE
SOUTH AUSTRALIA 5000
TEL: 08 8223 7800
engineers@secon.net.au
A.B.N. 30 613 300 299
A.C.N. 613 300 299

© COPYRIGHT SECON PTY. LTD. 2017			
North	DRAWN	AC	CHECKED
	ENG	SMG	Q.A.
	DATE	MAR '18	SCALE 1:100 @ A1
		SHEET	3 OF X
	DRAWING No.	B8014-H03	
PLOT DATE:	22/06/2018	Size	Rev.
		A1	1

0 1 2 3 4 5m
SCALE 1:100 AT ORIGINAL SIZE

BUILDING RULES

G:\Proj\B8014 - King William Street 97, Kent Town\Drawings\Working Drawings\B8014-H03.dwg