



ROOF LAYOUT  
SCALE 1:100

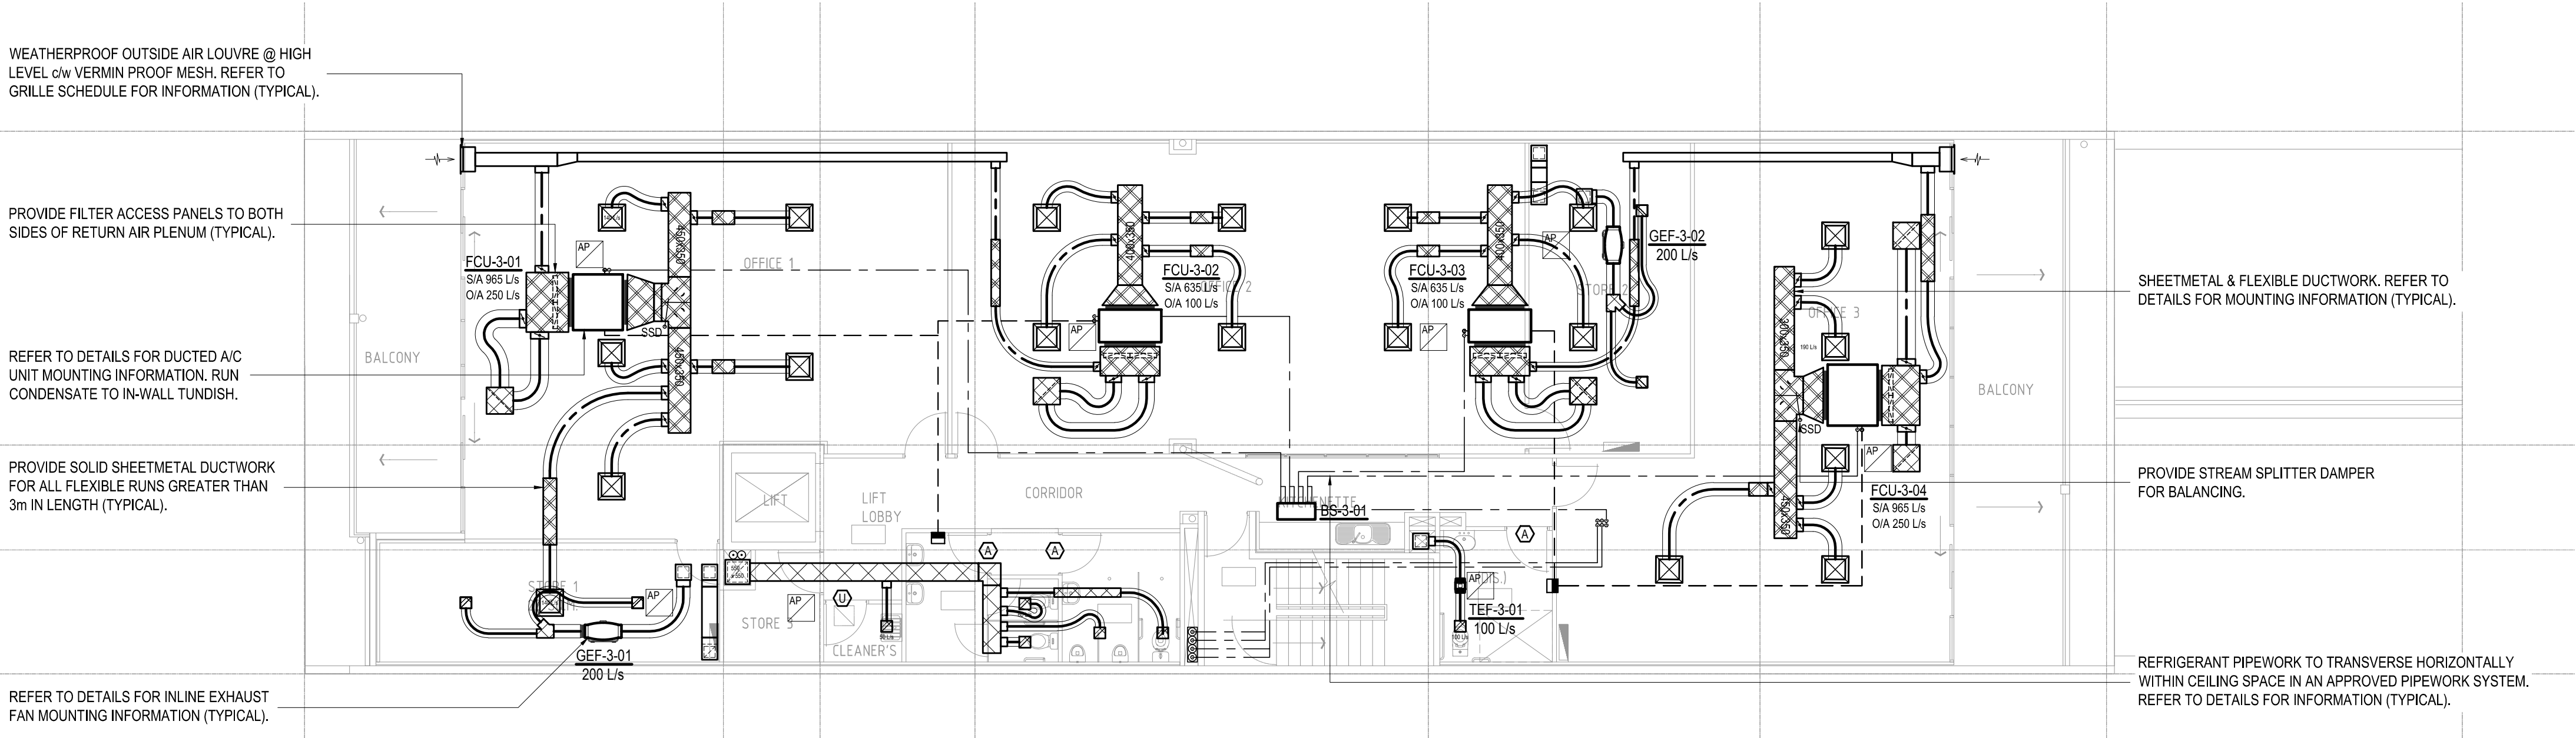

THIRD FLOOR PLAN  
SCALE 1:100

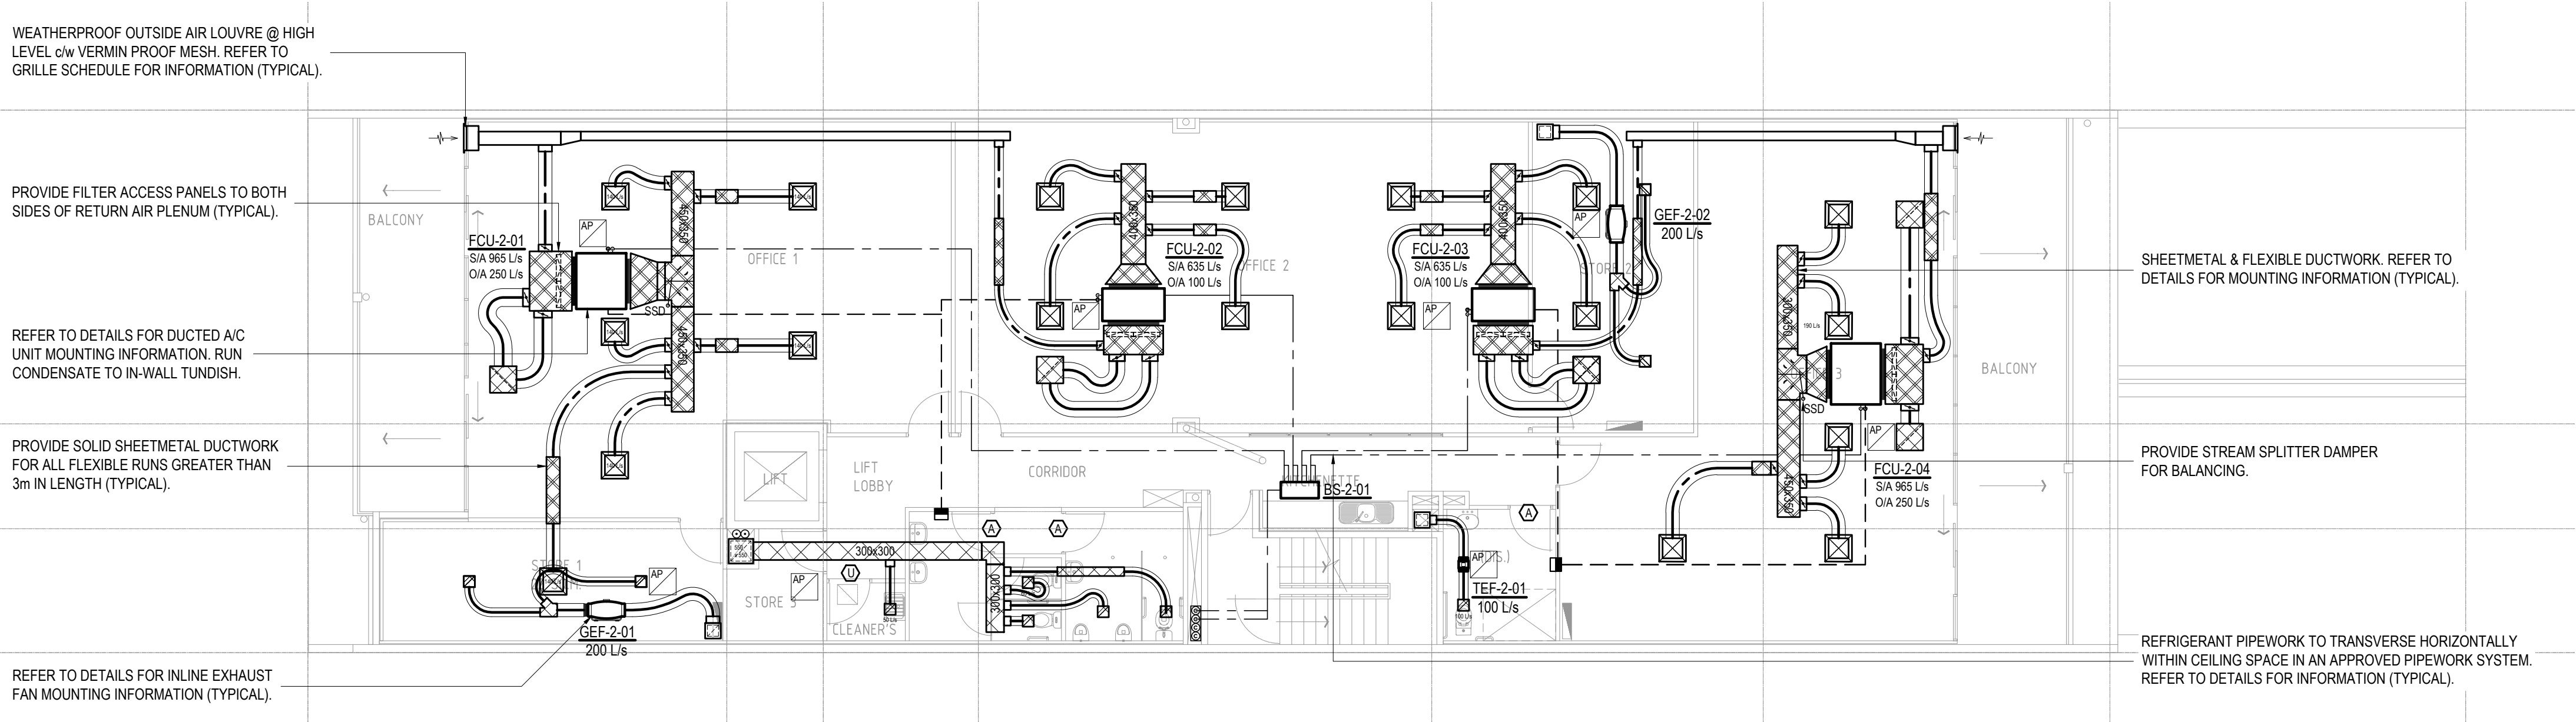

SECOND FLOOR PLAN  
SCALE 1:100

Project		PROPOSED COMMERCIAL DEVELOPMENT 97 KING WILLIAM STREET KENT TOWN	
Title		MECHANICAL SERVICES HVAC - SECOND & THIRD FLOOR & ROOF LAYOUT	
Architect		ANTHONYDONATOARCHITECTS Suite 5/59 Fullarton Road   Kent Town SA 5087 t. 08 8364 6888   f. 08 8364 5355   www.adarchitects.com.au	
© COPYRIGHT SECON PTY. LTD. 2017		DRAWN TB CHECKED AB ENG SMC Q.A. AB DATE MAR 18 SCALE 1:100 @ A1 SHEET 2 of 4 DRAWING No. B8014-M02	
PLOT DATE: 22/06/2018		Size: A1	Rev. 1