


**TYPE D/1 - ELEVATION B**

SCALE 1:100


**TYPE D/1 - FRONT ELEVATION A**

SCALE 1:100

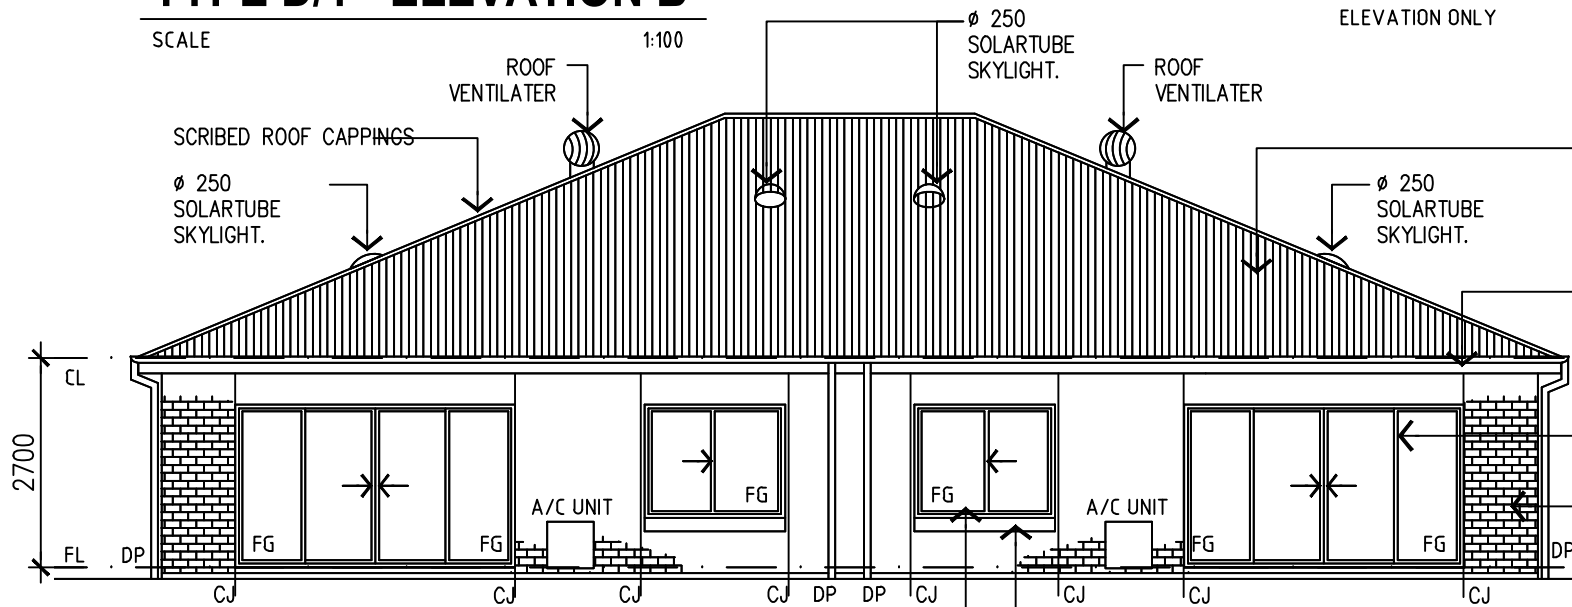

**TYPE D/1 - REAR ELEVATION C**

SCALE 1:100

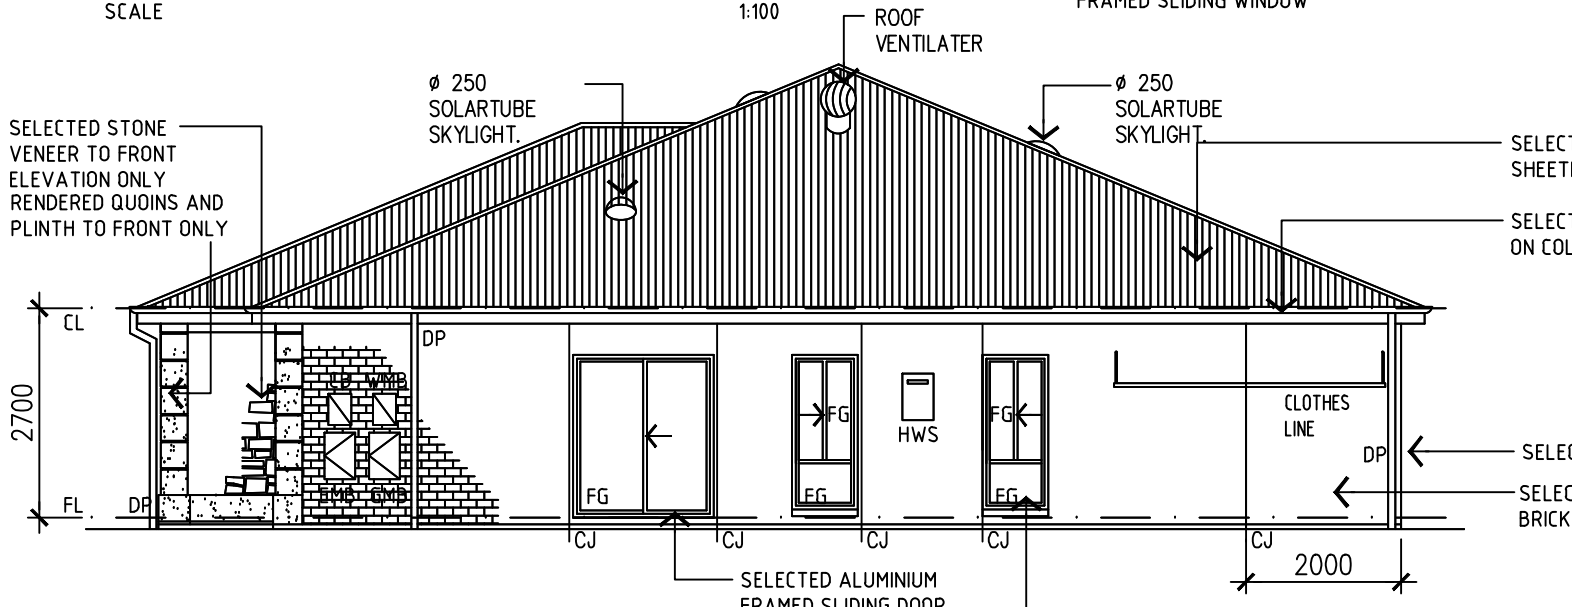

**TYPE D/1 - ELEVATION D**

SCALE 1:100

**LEGEND**


- FG FIXED GLASS
- CB COMMUNICATIONS BOX
- WMB WATER METER BOX
- GMB GAS METER BOX
- EMB ELECTRICAL METER BOX
- DP 90 mm DIAMETER UPVC DOWNPIPE, WITH LEAF GUARD, SUPPORTED BY STAND OFF BRACKETS.
- CJ CONTROL JOINT IN BRICKWORK TO FULL HEIGHT.

UNIT TYPE	UNIT NUMBERS
D/1	42, 43, 46, 47

**REVISIONS**

DATE	REV	DESCRIPTION	BY
20.08.18	A	TENDER ISSUE	

residential design  
commercial design  
industrial design  
project managers

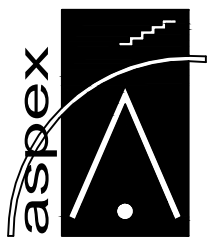

81 KING WILLIAM STREET  
KENT TOWN SA 5067  
P: 08 8130 3700 F: 08 8132 1109  
E: admin@aspexdesigners.com.au

© C O P Y R I G H T 2 0 1 3

PROJECT:  
THORNDON PARK ESTATE

SITE ADDRESS:  
LOT 52 RESERVOIR ROAD  
PARADISE

CLIENT:  
Mr. PAT BELPERIO

DRAWING TITLE:  
UNIT TYPE D/1 - ELEVATIONS

DRAWING NUMBER: WD04 A

DRAWN: CDP DATE: AUG 2018

SCALE: 1:100 JOB NO: TRI 2829

CONTRACTORS NOTE:  
CONTRACTORS ARE TO VERIFY ALL DIMENSIONS  
ON-SITE BEFORE COMMENCING ANY WORK. FIGURED  
DIMENSIONS SHALL TAKE PREFERENCE OVER  
SCALED DIMENSIONS, AND ANY DISCREPANCY  
SHALL BE REPORTED TO THE DESIGNER  
IMMEDIATELY.

**TENDER**  
20.08.18