
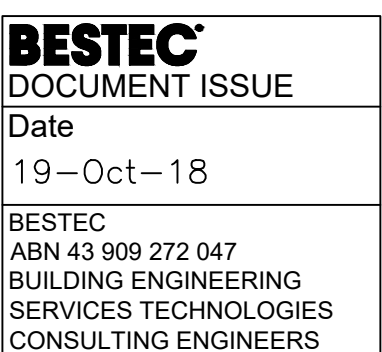


- E-401 SITE PLAN
- E-402 ELECTRICAL SINGLE LINE DIAGRAM
- E-403 TELECOMMUNICATIONS  
SCHEMATIC DIAGRAM & LEGEND  
OF SYMBOLS
- E-404 STAGE 4  
POWER ARRANGEMENT
- E-405 STAGE 4  
TELECOMMUNICATIONS & MATV  
ARRANGEMENT

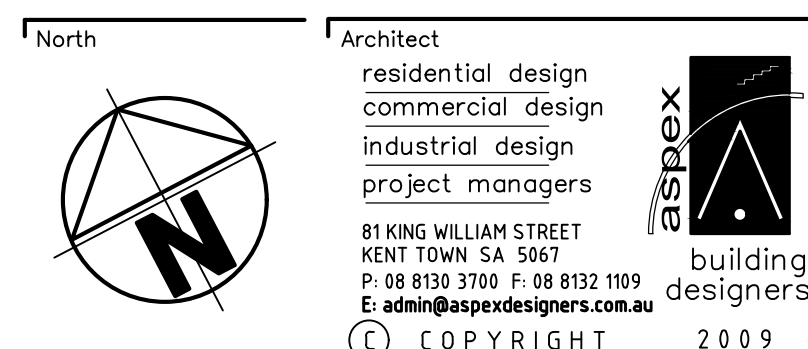

Project THORNDON PARK ESTATE RETIREMENT LIVING UNITS STAGE 4	Drawn RM	Checked <i>AB</i>	Date OCT 2018
Title ELECTRICAL SERVICES	Designed SMY	Checked <i>ST</i>	Scale 1:500 @A1
SITE PLAN	Drawing Number E-401	of 56099	Sheet 1 of 5 Issue

[illegible]

# BESTEC®

BESTEC  
ABN 43 909 272 047

T. (08) 8232 4442  
F. (08) 8232 4244  
E. [consulting@bestec.com.au](mailto:consulting@bestec.com.au)  
A. 144 Gawler Place  
Adelaide, 5000  
South Australia

G.P.O Box 818,  
Adelaide 5001

W. [bestec.com.au](http://bestec.com.au)