


P:\56099\Drawings\EL\EC\56099 E-402-403.dwg 19/10/2018 12:01:14 PM warren higgins


Issue	Amendments	Date	Init.

North

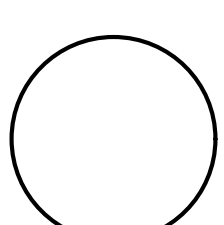

Architect

residential design
commercial design
industrial design
project managers

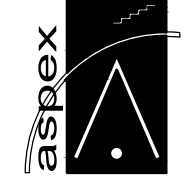
building
designers


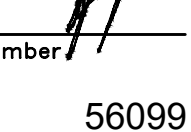
81 KING WILLIAM STREET
KENT TOWN SA 5067
P: 08 8130 3700 F: 08 8132 1109
E: admin@aspedesigners.com.au


© COPYRIGHT 2009

BESTEC®

BESTEC
ABN 43 909 272 047
T: (08) 8232 4442
F: (08) 8232 4244
E: consulting@bestec.com.au
A: 144 Gawler Place
Adelaide, 5000
South Australia
G.P.O Box 816,
Adelaide 5001
W: bestec.com.au

Project
THORNDON PARK ESTATE RETIREMENT LIVING UNITS
STAGE 4
Title
ELECTRICAL SERVICES
ELECTRICAL SINGLE LINE DIAGRAM

Drawn RM	Checked 	Date OCT 2018
Designed SMY	Checked 	Scale NTS
Drawing Number E-02	Sheet 5	Issue @A1

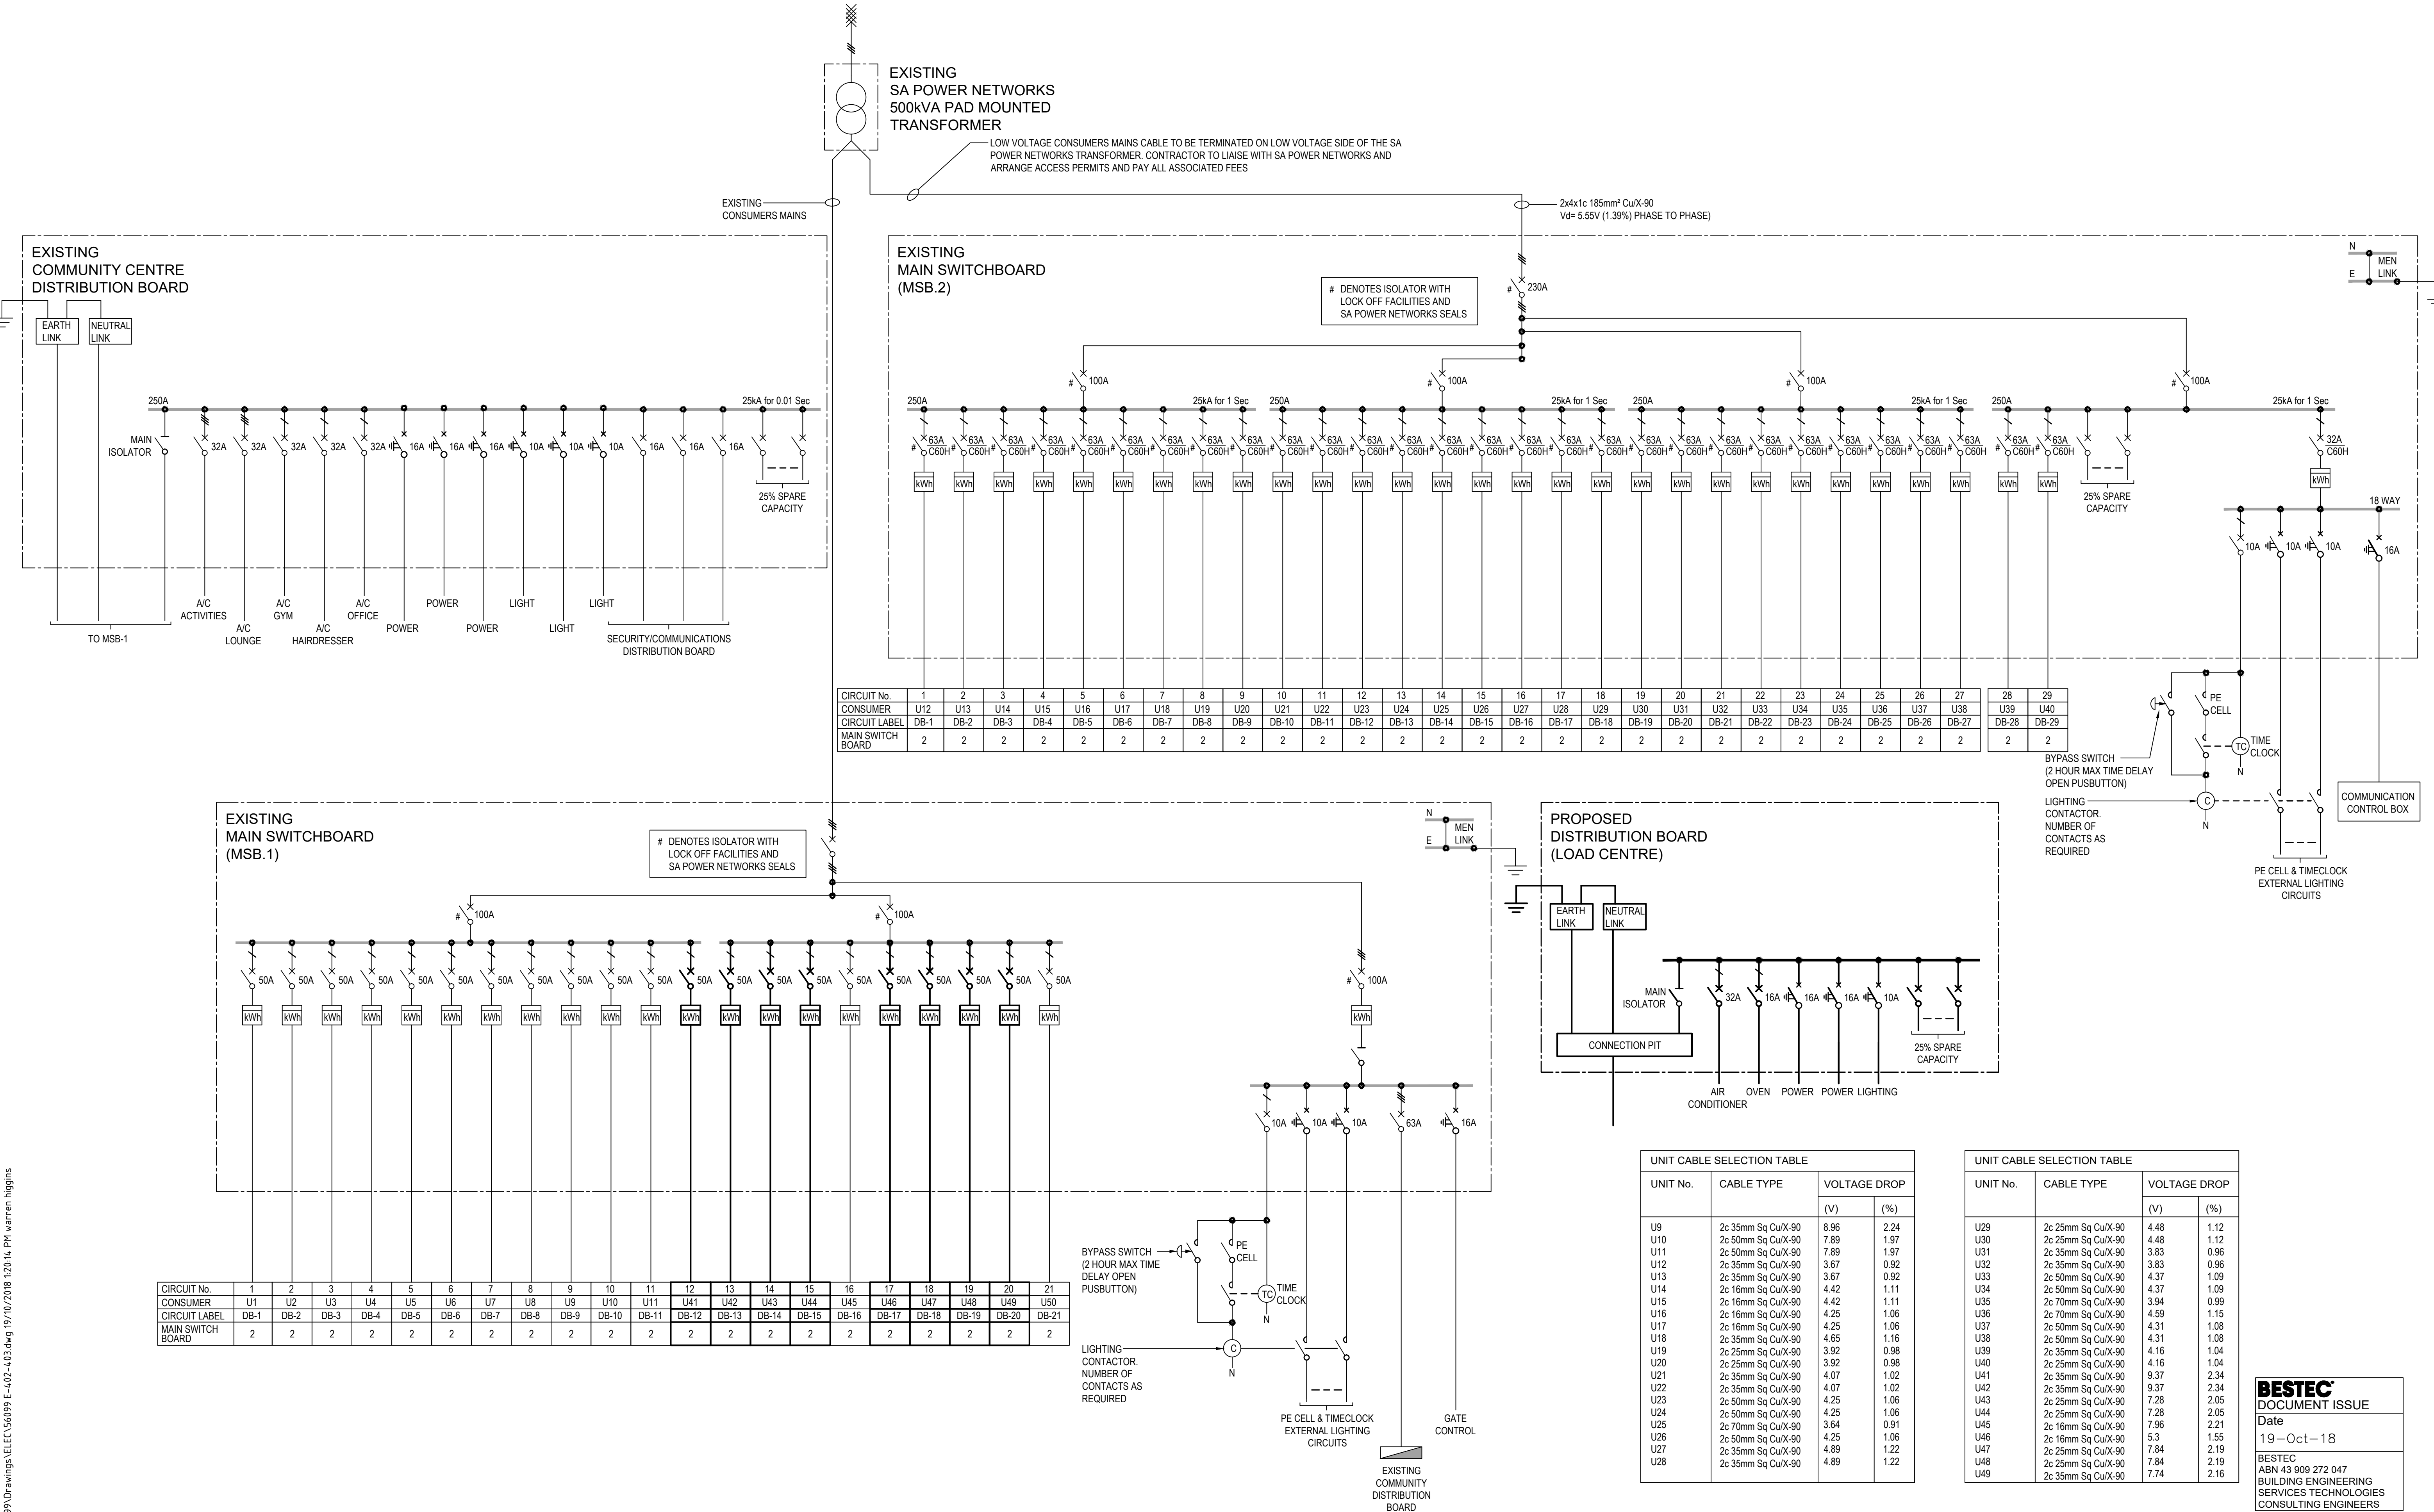

TENDER ISSUE