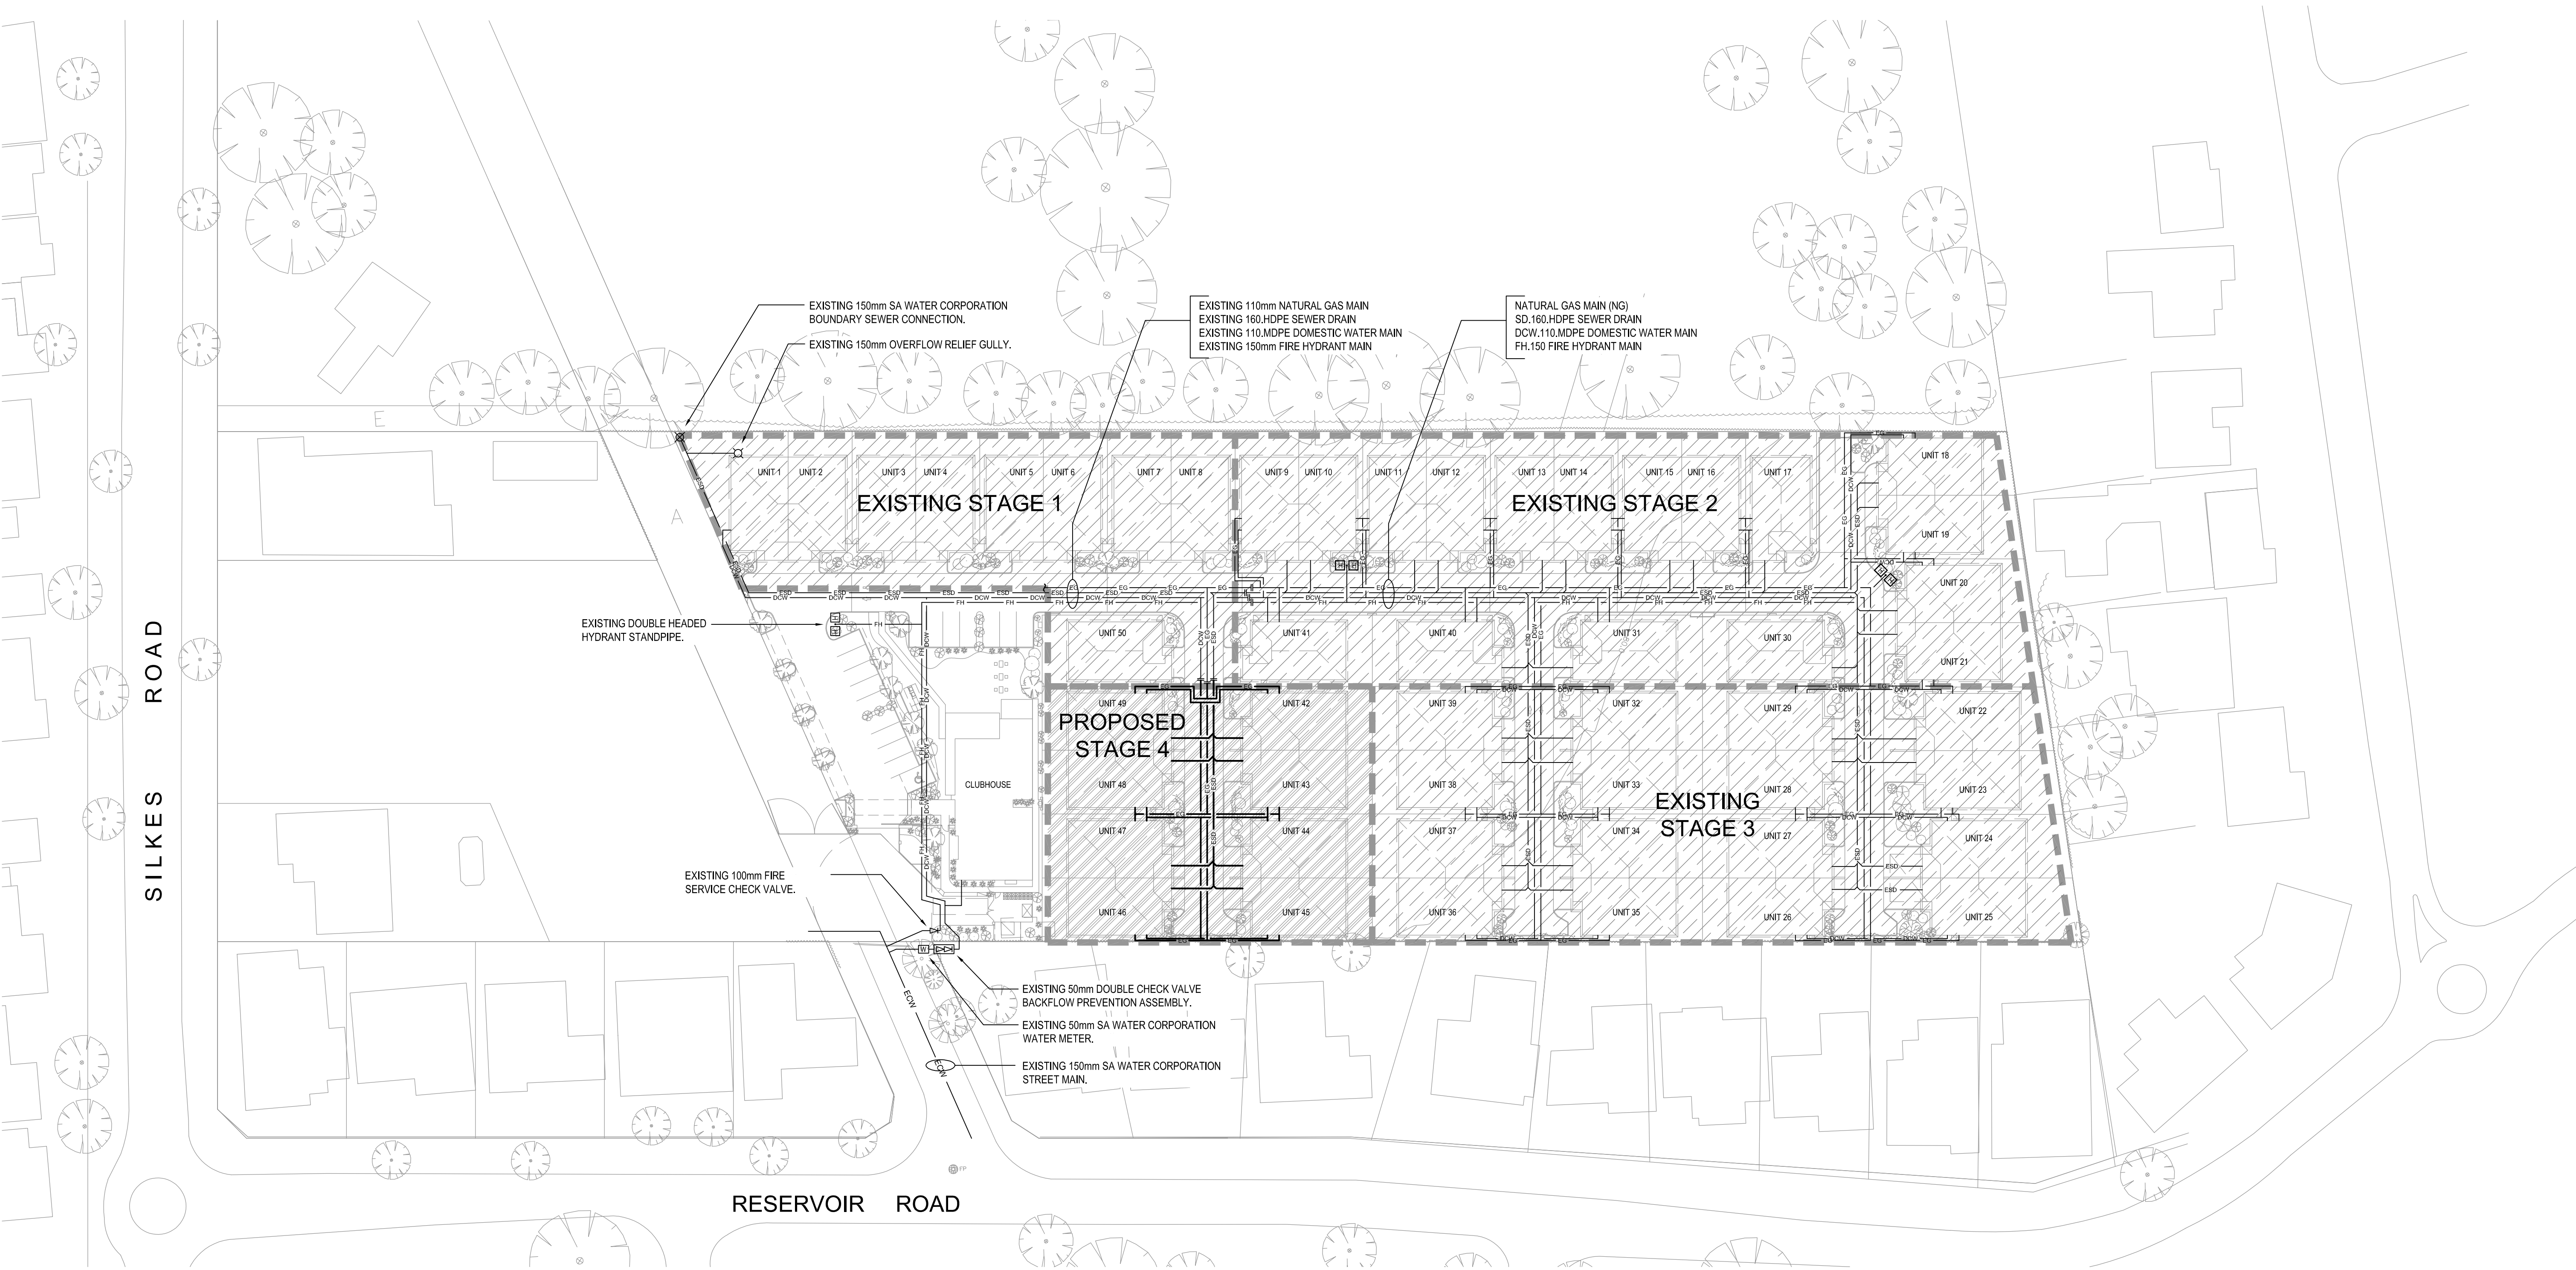


DRAWING INDEX

- H-01 SITE PLAN
- H-02 PROPOSED SEWER DRAINAGE ARRANGEMENT
- H-03 PROPOSED DOMESTIC COLD WATER, NATURAL GAS & FIRE HYDRANT RETICULATION ARRANGEMENT



BESTEC
DOCUMENT ISSUE

Date
19-Oct-18

BESTEC
ABN 43 909 272 047
BUILDING ENGINEERING
SERVICES TECHNOLOGIES
CONSULTING ENGINEERS


TENDER ISSUE

Issue	Amendments	Date	Init.


North

Architect

residential design
commercial design
industrial design
project managers


building
designers

 
 
81 KING WILLIAM STREET
KENT TOWN SA 5067
P: 08 8130 3700 F: 08 8132 1169
E: admin@aspeXdesigners.com.au

 COPYRIGHT 2009



BESTEC
ABN 43 909 272 047
T. (08) 8232 4442
F. (08) 8232 4244
E. consulting@bestec.com.au
A. 144 Gawler Place
Adelaide, 5000
South Australia
G.P.O Box 818,
Adelaide 5001
W. bestec.com.au

Project THORNDON PARK ESTATE RETIREMENT LIVING UNITS STAGE 4
Title HYDRAULIC SERVICES
SITE PLAN

Drawn JVE	Checked 	Date OCT 2018
Designed JUH	Checked 	Scale 1:500 @A1
Drawing Number H-01	Sheet 56099 1	Issue 3