

ROOF LEGEND:

- FALL

→

ROOF FALL, ROOF PITCH TO BE 22.5° UNLESS NOTED OTHERWISE
- GF

→

GUTTER FALL MIN 1:200
- RH

ROOF MOUNTED COWEL. CONNECTED TO RANGEHOOD BELOW. PROVIDE FLASHINGS TO ENSURE A NEAT WEATHERTIGHT JUNCTION.
- DP

90 mm DIAMETER COLORBOND STEEL DOWNPIPE, SUPPORTED BY STAND OFF BRACKETS.
- V

COLORBOND ROOF VENTILATOR

UNIT TYPE	UNIT NUMBERS
D / 1	42, 43, 46, 47

REVISIONS

DATE	REV	DESCRIPTION	BY
20.08.18	A	ISSUED FOR TENDER	

- residential design
- commercial design
- industrial design
- project managers



81 King William Street
KENT TOWN SA 5067
P: 08 8130 3700 F: 08 8132 1109
E: admin@aspexdesigners.com.au

© C O P Y R I G H T 2009

PROJECT:
PROPOSED RETIREMENT VILLAGE

SITE ADDRESS:
LOT 52 RESERVOIR ROAD
PARADISE

CLIENT:
Mr. PAT BELPERIO

DRAWING TITLE:
UNIT TYPE E/1 – ROOF DRAINAGE PLAN


DRAWING NUMBER: WD21 A

DRAWN: APB/GZ DATE: AUG 2018

SCALE: 1:100 JOB NO: BEL 1353

CONTRACTORS NOTE:
CONTRACTORS ARE TO VERIFY ALL DIMENSIONS ON-SITE BEFORE COMMENCING ANY WORK. FIGURED DIMENSIONS SHALL TAKE PREFERENCE OVER SCALED DIMENSIONS, AND ANY DISCREPANCY SHALL BE REPORTED TO THE DESIGNER IMMEDIATELY.

NOTE
SKYLIGHTS TO BE NO CLOSER THAN 900mm FROM PARTY WALL.

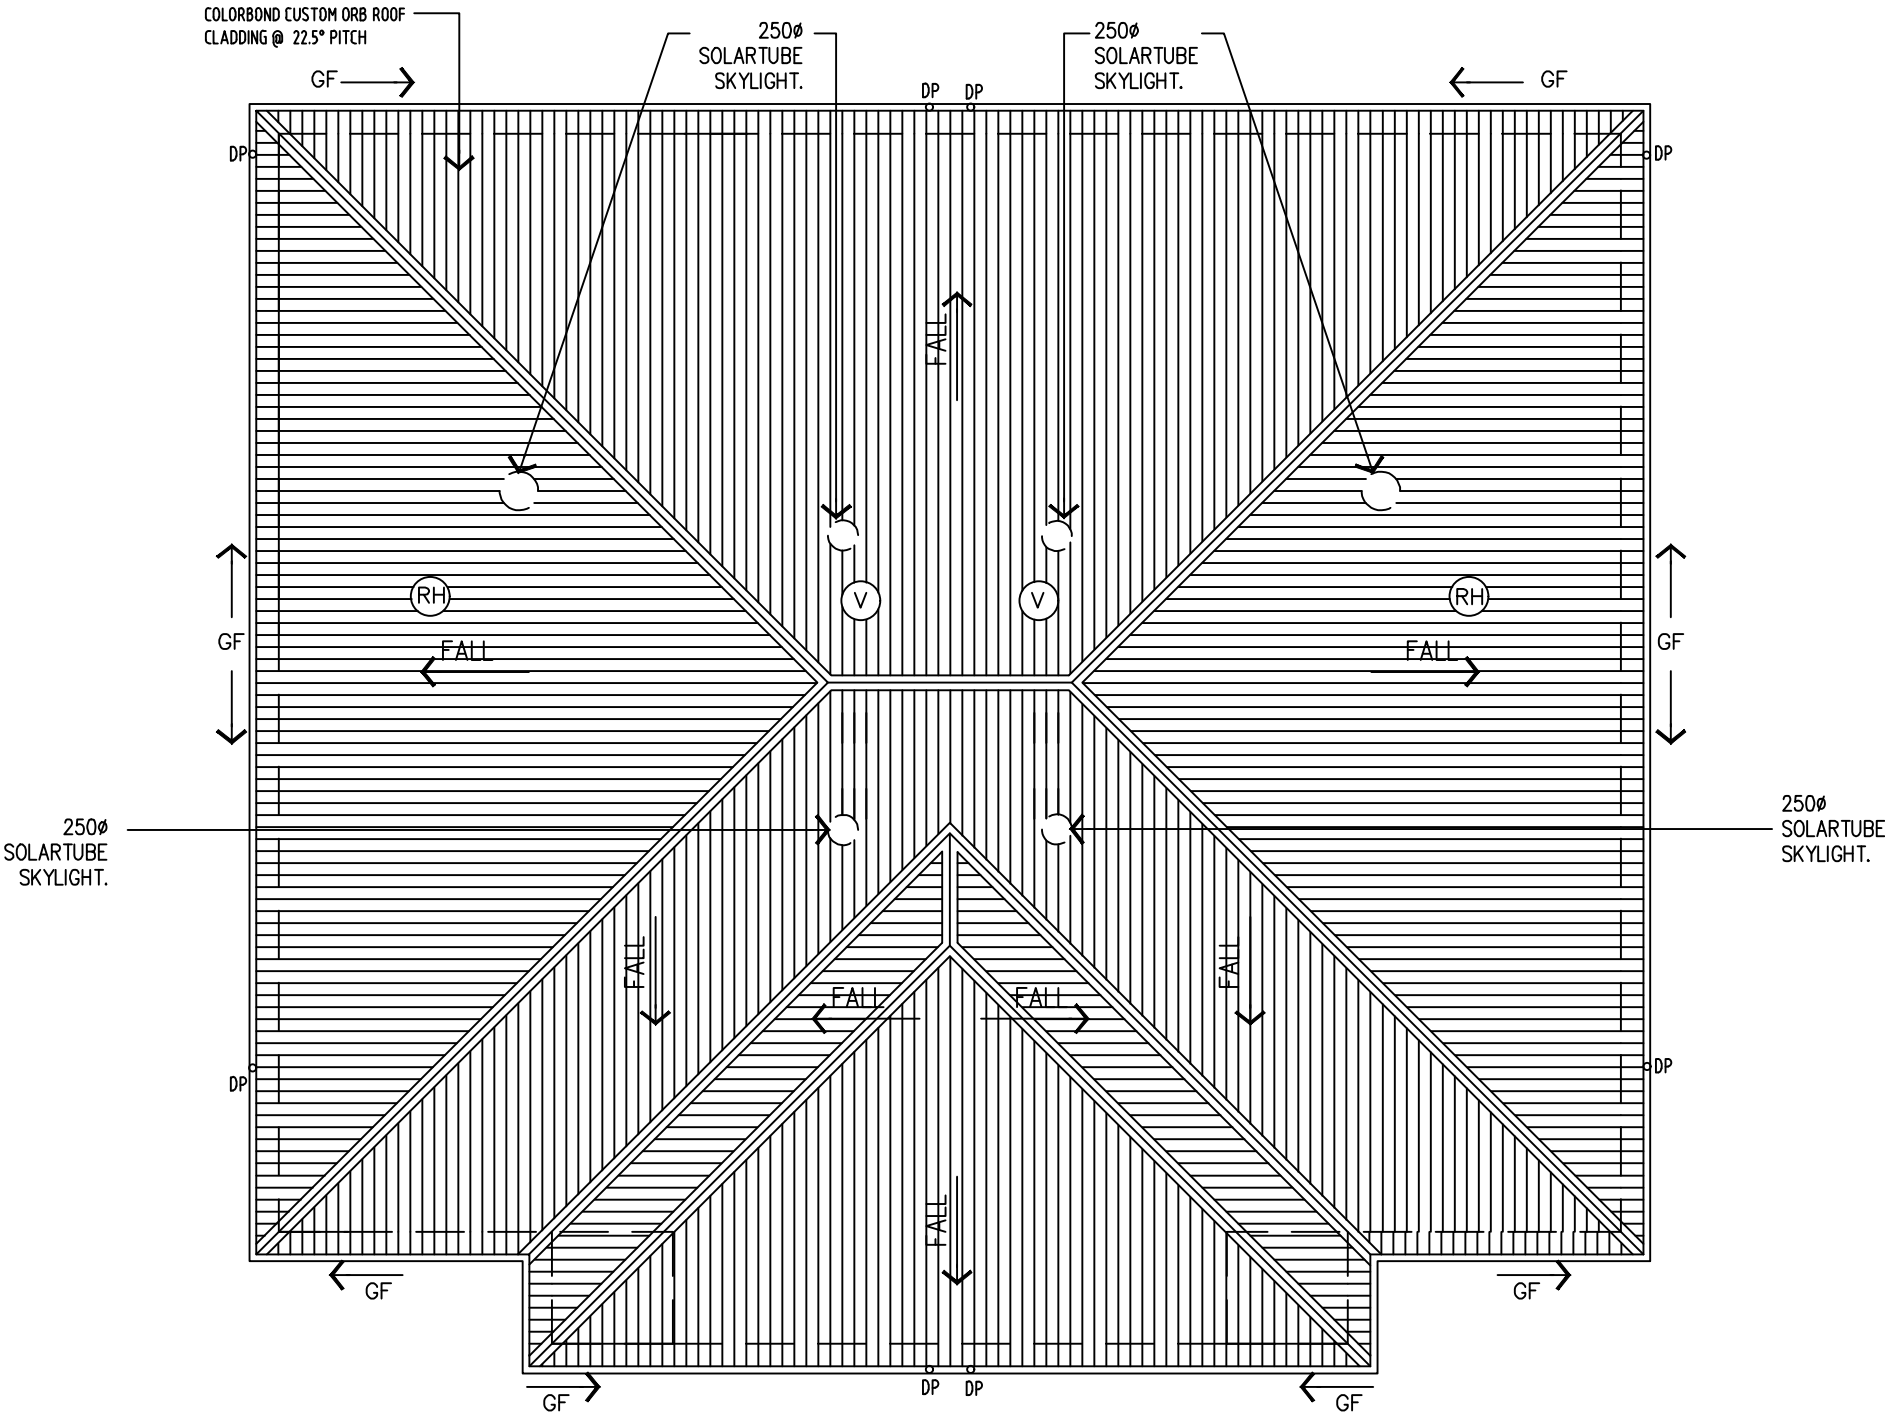

ROOF DRAINAGE PLAN - TYPE D/1

SCALE 1:100

TENDER
20.08.18