


FALL →	ROOF FALL, ROOF PITCH TO BE 22.5° UNLESS NOTED OTHERWISE
GF →	GUTTER FALL MIN 1:200
RH	ROOF MOUNTED COWEL. CONNECTED TO RANGEHOOD BELOW. PROVIDE FLASHINGS TO ENSURE A NEAT WEATHERTIGHT JUNCTION.
o DP	90 mm DIAMETER COLORBOND STEEL DOWNPIPE, SUPPORTED BY STAND OFF BRACKETS.
V	COLORBOND ROOF VENTILATOR

UNIT TYPE	UNIT NUMBERS
D / 3	44, 45

DATE	REV	DESCRIPTION	BY
20.08.18	A	ISSUED FOR TENDER	



aspex  
building  
designers

81 King William Street  
KENT TOWN SA 5067  
P: 08 8130 3700 F: 08 8132 1109  
E: [admin@aspexdesigners.com.au](mailto:admin@aspexdesigners.com.au)  
© C O P Y R I G H T 2009

PROJECT:  
PROPOSED RETIREMENT VILLAGE

SITE ADDRESS:  
LOT 52 RESERVOIR ROAD  
PARADISE

CLIENT:  
Mr. PAT BELPERIO


DRAWING TITLE:  
UNIT TYPE E/1 - ROOF DRAINAGE PLAN

DRAWING NUMBER:	WD21 A
-----------------	--------

DRAWN: APB/GZ DATE: AUG 2018

SCALE: 1:100 JOB NO:BEL 1353

CONTRACTORS NOTE:  
CONTRACTORS ARE TO VERIFY ALL DIMENSIONS  
ON-SITE BEFORE COMMENCING ANY WORK.  
FIGURED DIMENSIONS SHALL TAKE PREFERENCE  
OVER SCALED DIMENSIONS, AND ANY  
DISCREPANCY SHALL BE REPORTED TO THE  
DESIGNER IMMEDIATELY.

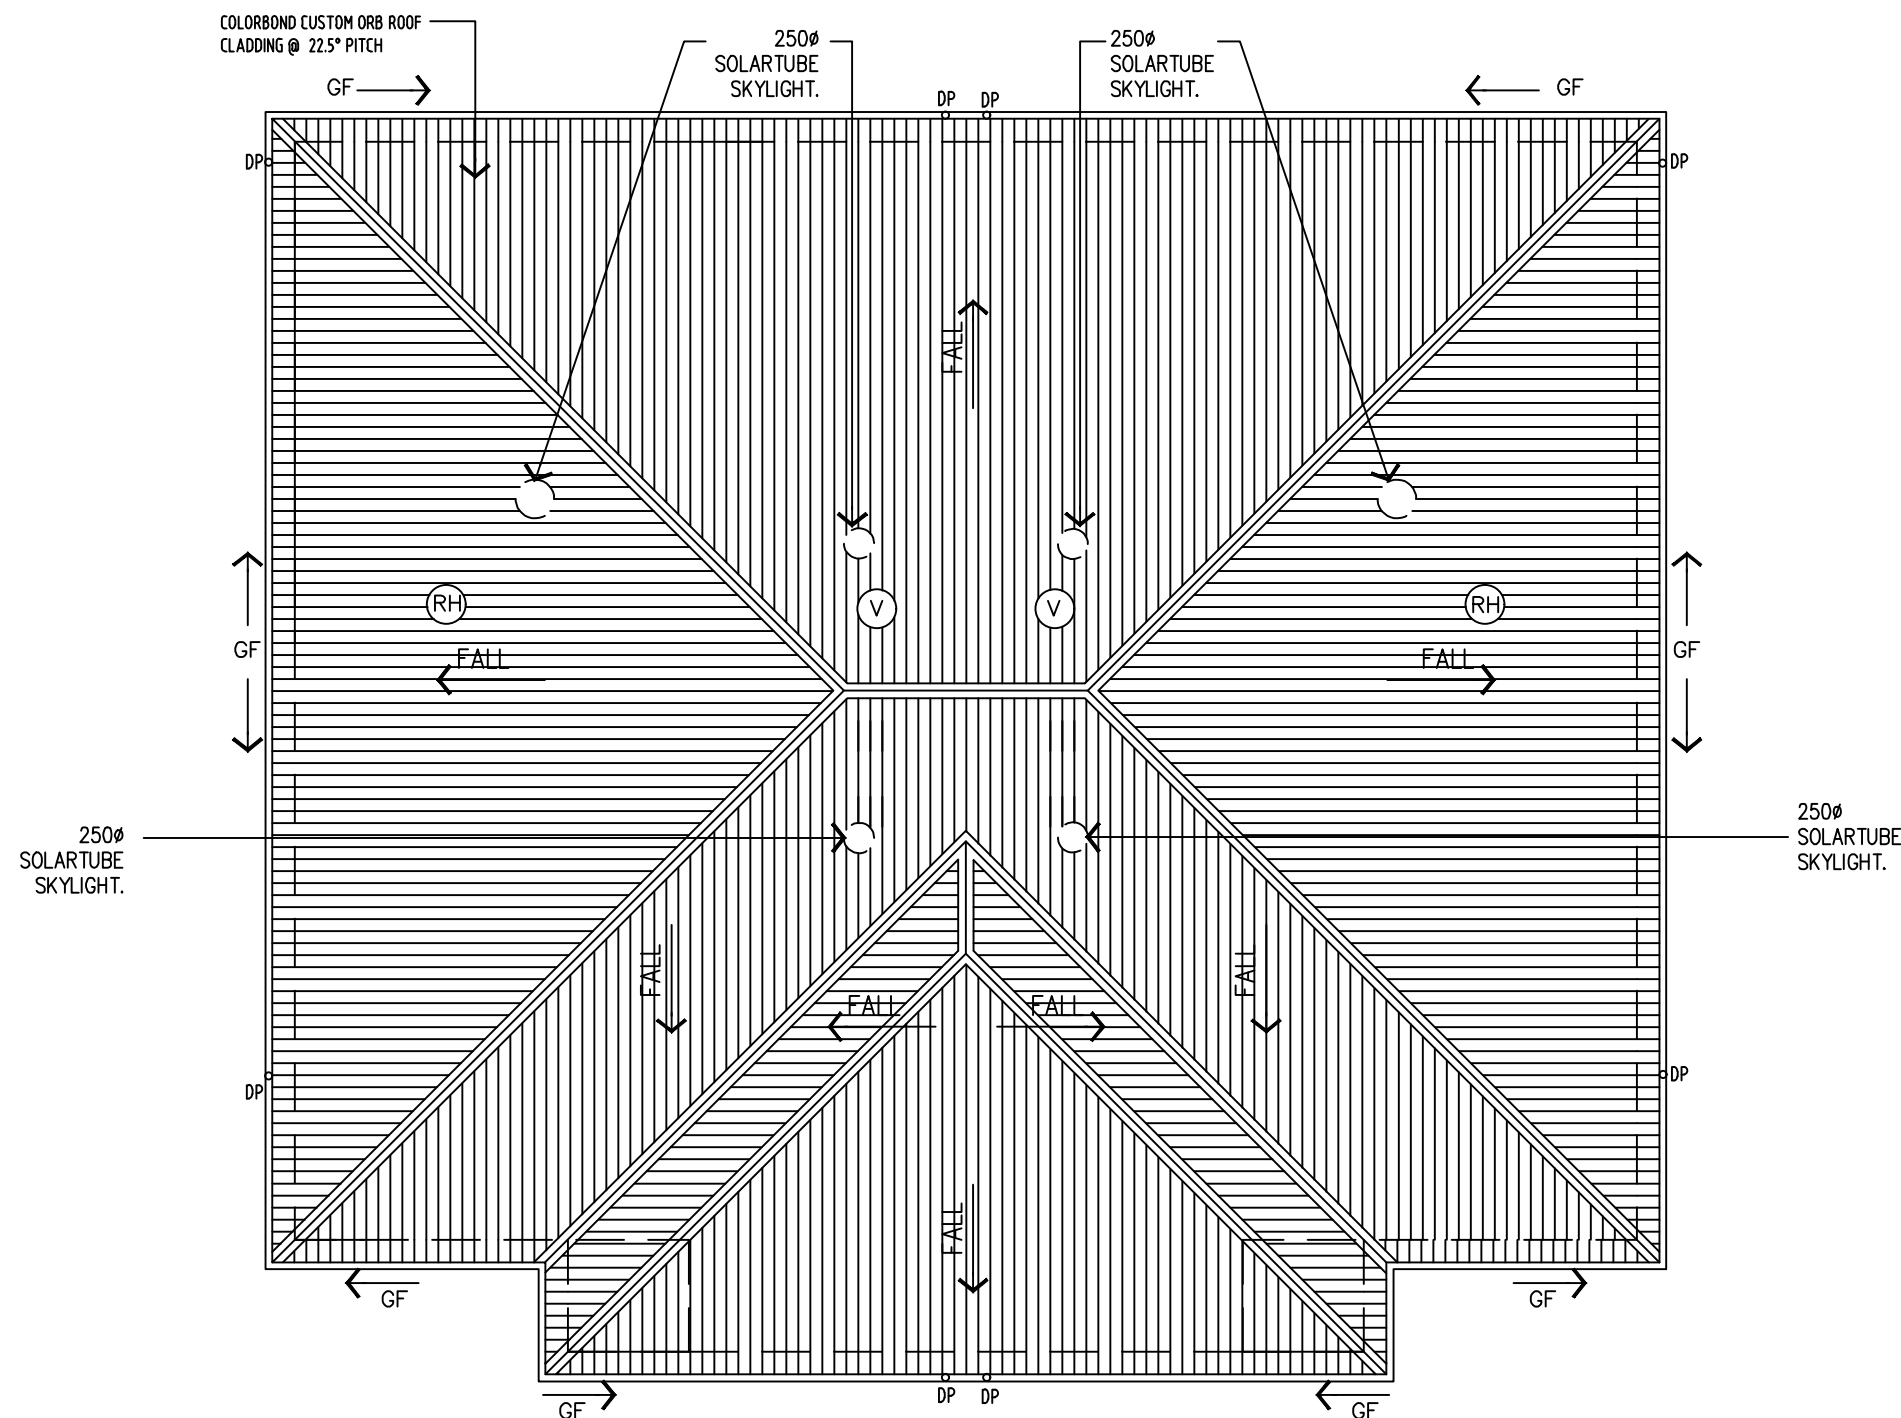

## ROOF DRAINAGE PLAN - TYPE D/3

SCALE

---

1:100

**TENDER**  
20.08.18